


THE INFORMATION AND DATA CONTAINED IN THIS DRAWING IS CONFIDENTIAL, PROPRIETARY IN NATURE AND SUBJECT TO COPYRIGHT, AND MAY NOT BE REPRODUCED, COPIED, REPRODUCED, ALTERED, CHANGED, MODIFIED, ADAPTED, REPRODUCED, OR UTILIZED IN ANY FORM WITHOUT THE EXPRESS PERMISSION OF CONOCOPhillips CANADA.

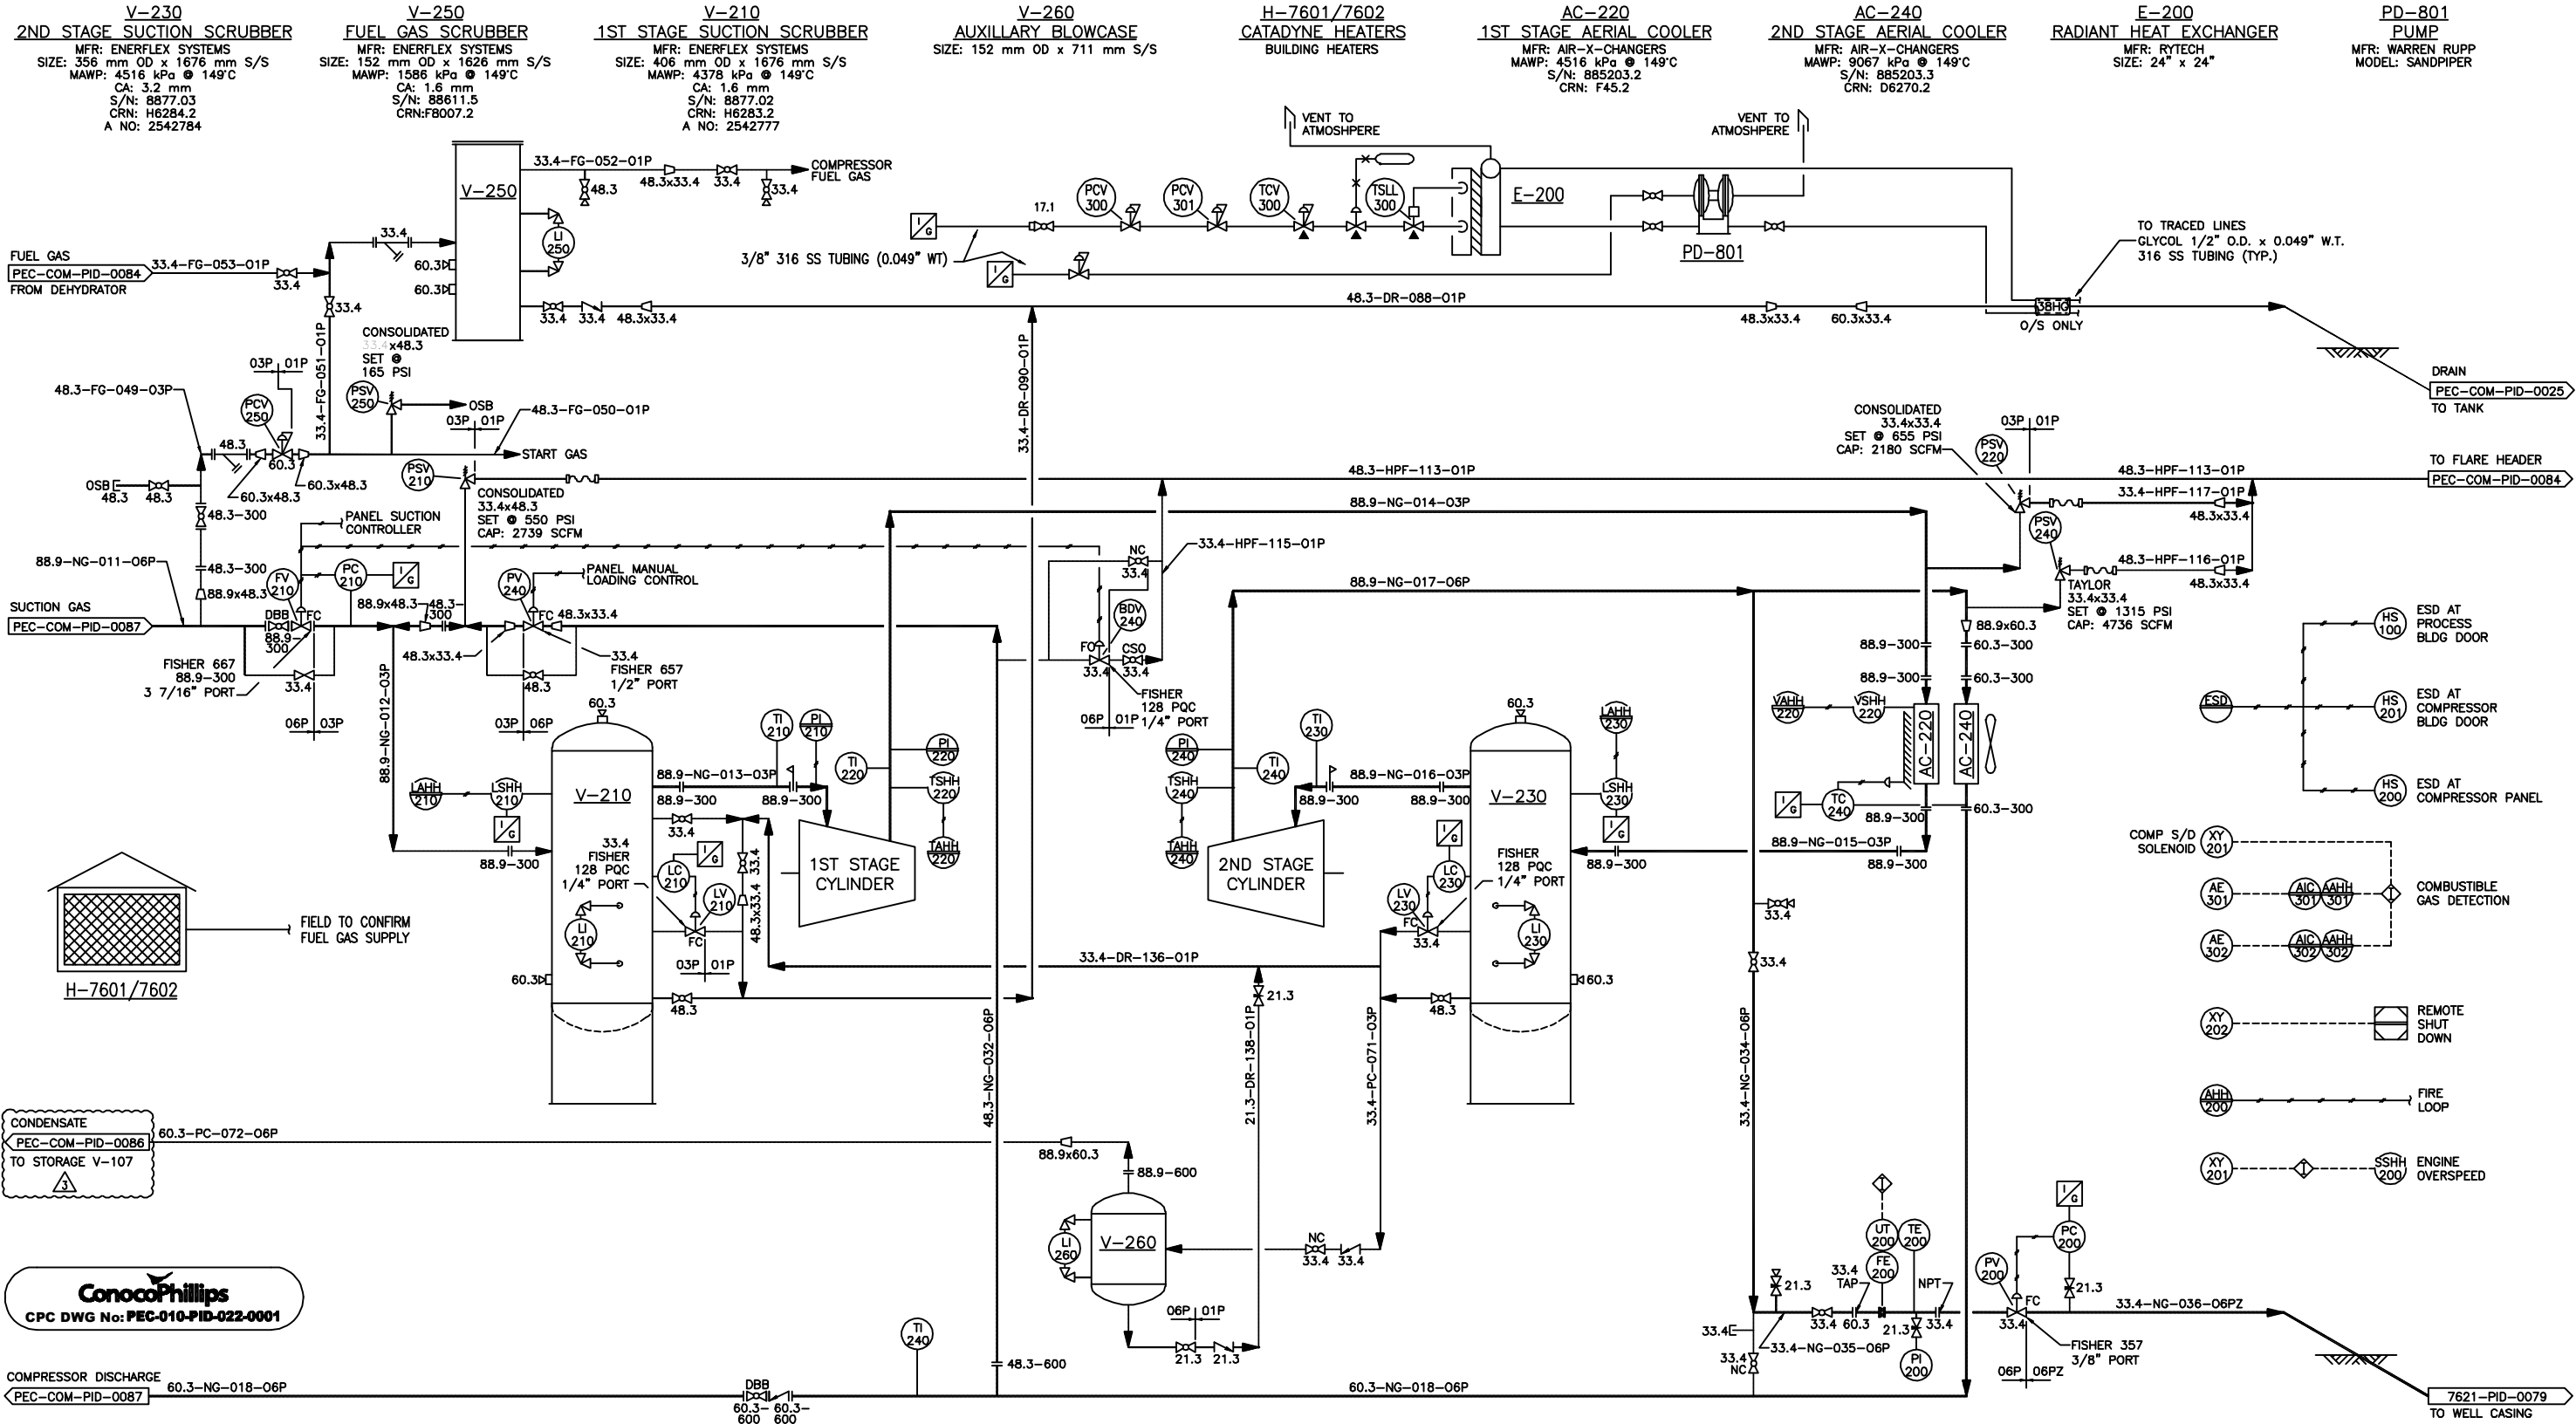

| REFERENCE DRAWINGS |                                           |
|--------------------|-------------------------------------------|
| DWG. NO.           | TITLE                                     |
| 97CN-003           | COMP BLDG, INLET HDR, AND LINE HTR P & ID |
|                    | PREVIOUSLY KNOWN AS PEC-COM-PID-0088      |
|                    |                                           |
|                    |                                           |
|                    |                                           |
|                    |                                           |
|                    |                                           |
|                    |                                           |

| REVISIONS |          |     |       |     |       |                                 |
|-----------|----------|-----|-------|-----|-------|---------------------------------|
| REV.      | DATE     | BY  | CHK'D | ENG | APP'D | REVISION ISSUE                  |
| 1         | 06 03 11 | JDM | SMK   |     |       | AS-IS (CS2A29100/DD)            |
| 2         | 08/09/17 | CPC |       |     |       | REVISED PER MOC# 14485 (BY CPC) |
| 3         | 08/10/17 | TPS | ADR   |     |       | ADD V-107 (CS2022900/LWC)       |
|           |          |     |       |     |       |                                 |
|           |          |     |       |     |       |                                 |
|           |          |     |       |     |       |                                 |
|           |          |     |       |     |       |                                 |

ENGINEERING SEAL

PERMIT

|                 |                  |
|-----------------|------------------|
| PREPARED BY:    |                  |
| CRIMTECH        |                  |
| DESIGNED:       | DATE: (YY/MM/DD) |
| DRAWN:          | 06 03 11         |
| CHECKED:        | 06 07 28         |
| PROCESS CK.:    |                  |
| STRUCT. CK.:    |                  |
| ELECT. CK.:     |                  |
| INSTR. CK.:     |                  |
| ENG. CO. APPR.: |                  |
| CLIENT APPR.:   |                  |

|                                                  |                   |                                 |                  |
|--------------------------------------------------|-------------------|---------------------------------|------------------|
| ConocoPhillips<br>Canada Resources Corp.         |                   |                                 |                  |
| PECO 07-23 COMPRESSOR SITE                       |                   |                                 |                  |
| COMPRESSOR<br>PIPING AND INSTRUMENTATION DIAGRAM |                   |                                 |                  |
| LEGAL DESC. FROM:<br>07-23-047-16 WSM            |                   | LEGAL DESC. TO (IF APPLICABLE): |                  |
| ENG. CO. PROJ. NO.:<br>2A29100                   | SCALE:<br>NTS     | DESIGN:<br>CPC DWG. NO.:        | REV.:<br>3       |
| ENG. CO. DWG. NO.:                               | DATE:<br>06 03 11 | DRAWN:<br>A/J                   | PEC-COM-PID-0088 |