
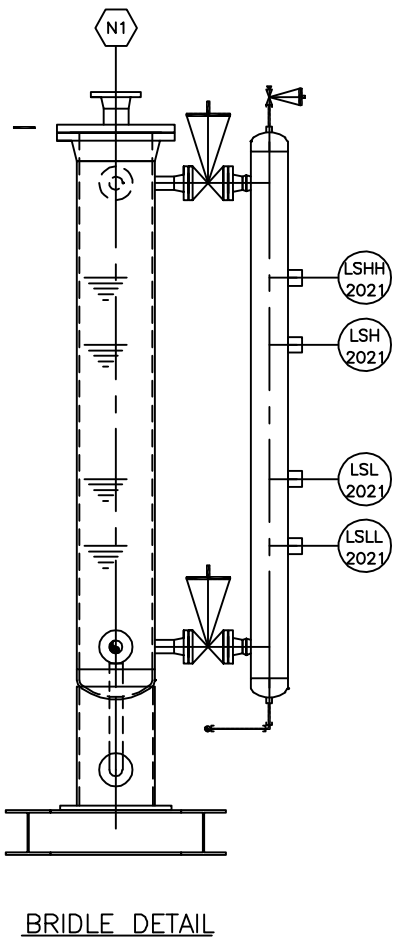
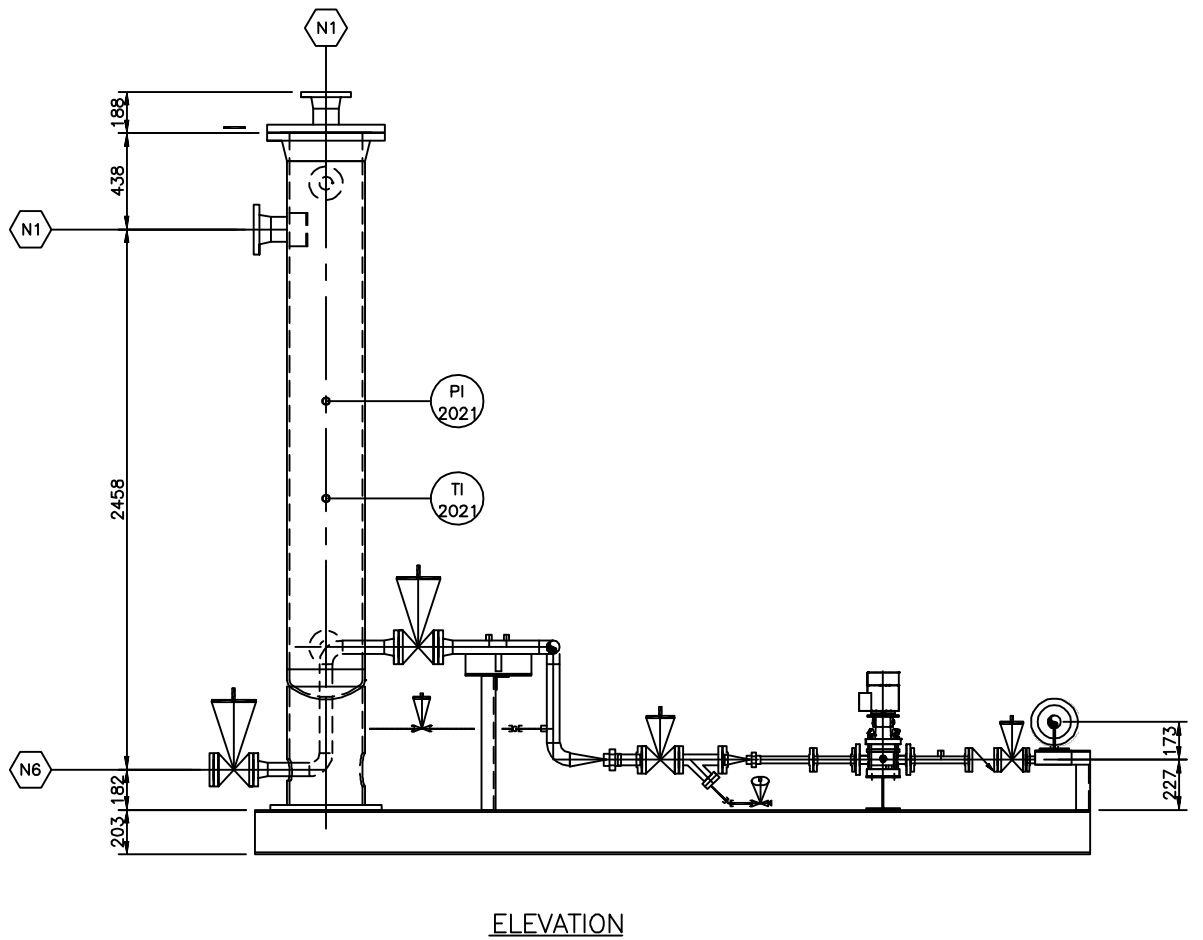


This print and information portrayed there-on must not be reproduced or extracted without the permission of Burlington Resource Canada Ltd

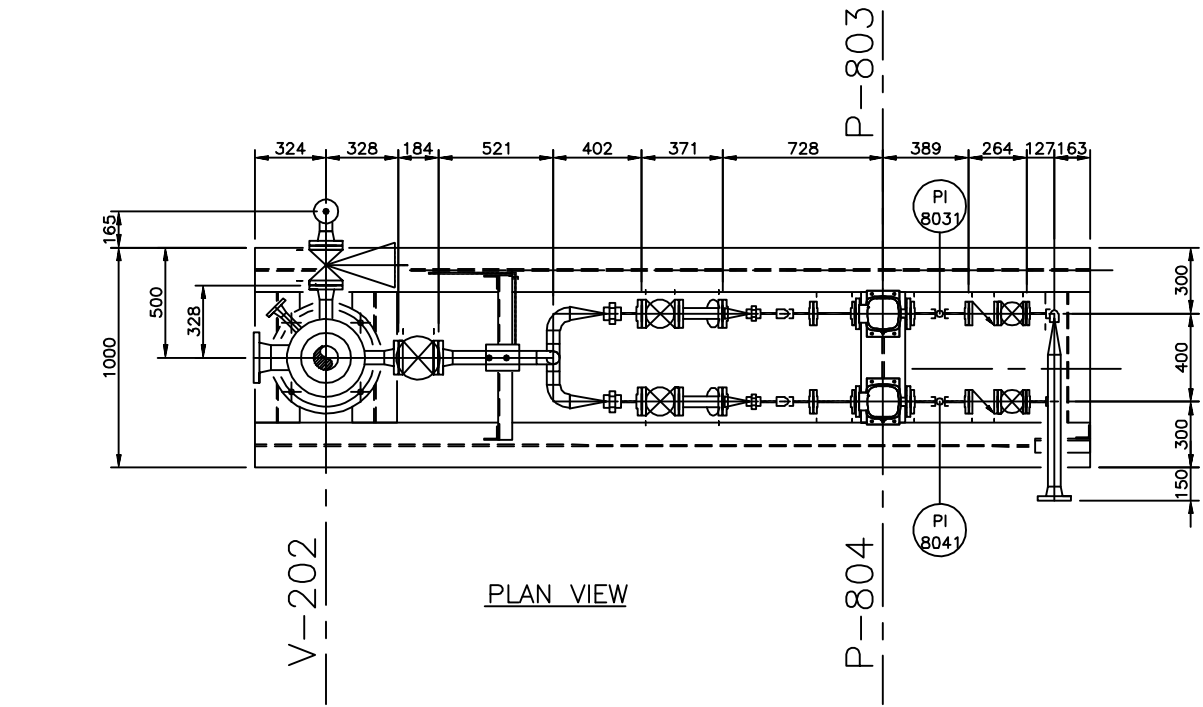

-	-
REFERENCE DRAWINGS	DWG No


0	08.11.20	ADDED CPC DRAWING NUMBER	CDL
A	04.06.18	PRELIMINARY	PAL
REV	DATE	REVISION DESCRIPTION	BY

ENGINEER	G.EVERETT		
APPROVAL			
CHECKER			
DRAWN	PAL		
DATE	04.06.18		
SCALE:	1:30	APPROVED	DATE

LICENCE AND PERMIT

BRASSEY CENTRAL FACILITIES ACID GAS RUNDOWN SKID PIPING PLAN d-13-F/93-P-10		BURLINGTON RESOURCE
BRC (HUNTER) LTD		
PLANT No	DRAWING No	
03.010	401.01	

 181





-	-
REFERENCE DRAWINGS	DWG No

0	08.11.20	ADDED CPC DRAWING NUMBER	CDL
A	04.06.18	PRELIMINARY	PAL
REV	DATE	REVISION DESCRIPTION	BY

ENGINEER	G.EVERETT		
APPROVAL			
CHECKER			
DRAWN	PAL		
DATE	04.06.18		
SCALE:	1:300	APPROVED	DATE

LICENCE AND PERMIT


BRASSEY CENTRAL FACILITIES V-202 ACID GAS RUNDOWN DRUM d-13-F/93-P-10		
BRC (HUNTER) LTD	PLANT No 03.010	DRAWING No 401.30

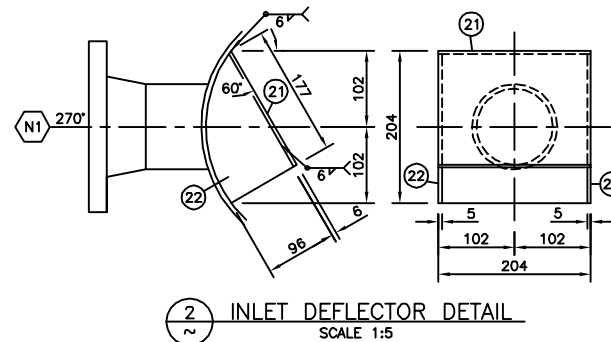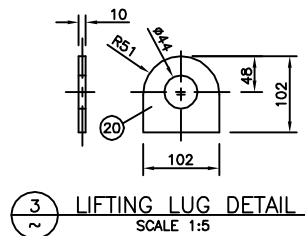

5,10,11,12,24	M1	1	14"	150#	10S	RFSO	MANWAY	3	-
-	-	-	-	-	-	-	-	-	-
9	C2	1	1"	3000#	-	CPLG	PI	6	-
9	C1	1	1"	3000#	-	CPLG	TI	6	-
-	-	-	-	-	-	-	-	-	-
7,15,16,26	N6	1	2"	150#	40S	RFWN	DRAIN	2,5	-
SEE DWG.#3601-B551	N5 A/B	2	1"	150#	40S	RFWN	HEATING COIL	-	-
7,18	N4 A/B	2	2"	150#	40S	RFWN	BRIDLE CONNECTION	2,4	-
7,16,17,25	N3	1	2"	150#	40S	RFWN	PUMP SUCTION	2,5	-
6,13	N2	1	4"	150#	40S	RFWN	OUTLET	2,4	-
6,14	N1	1	4"	150#	40S	RFWN	INLET	2,4	-
ITEMS	MK. NO.	NO.	SIZE	RATING	SCH	TYPE	SERVICE	W.D.	RE-PAD


G N			 PLAINS OIL LTD		
	DRAWN C.KIRKPATRICK	DATE 04-06-29	CUSTOMER/PROJECT/LOCATION BURLINGTON RESOURCES CANADA LTD. BRASSEY CENTRAL FACILITIES LSD: d-13-f/93-P-10		
	CHECKED RAN	DATE 04-06-30			
	ENG. APP'L	DATE			
	PROD. APP'L	DATE			
JOB NO. 3601		SCALE 1:10	DRAWING NO. 3601-B501		REV. 0

[illegible]

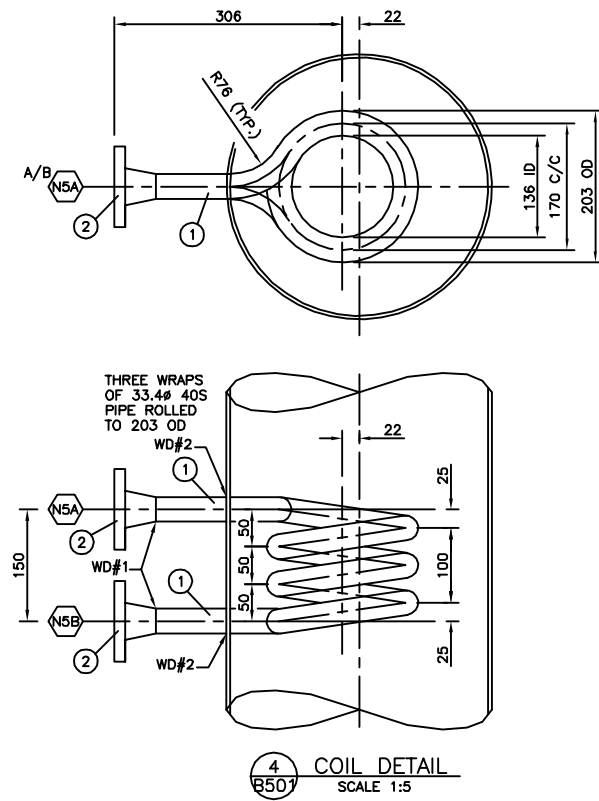

BILL OF MATERIAL			
ITEM	QTY.	DESCRIPTION	MAT'L SPEC.
1	1	1"-SCH 40S SMLS PIPE x 1940± LG	SA-312-TP304
2	2	1"-150# ASME RFWN FLANGE x SCH 40S BORE	SA-182-F304
3	1	4.76 PLATE x 360 ID x 483 OD	SA-240-304
4	-	-	-
5	-	-	-
6	-	-	-
7	-	-	-
8	-	-	-
9	-	-	-
10	-	-	-
11	-	-	-
12	-	-	-
13	-	-	-
14	-	-	-

MATERIAL LISTED FOR ONE
ONE REQ'D

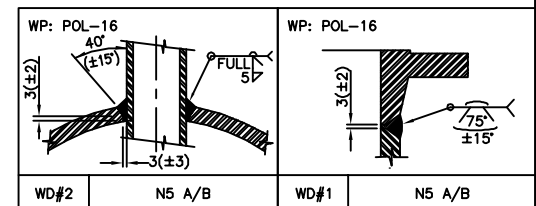

REFERENCE DRAWINGS		REVISIONS										GENERAL NOTES		 PLAINS OIL LTD	
DWG. NO.	DESCRIPTION	NO.	DATE	BY	APP'D	DESCRIPTION	NO.	DATE	BY	APP'D	DESCRIPTION	SHIPPING WT. INCL. ON DWG.#3601-B501	1.) ALL ATTACHMENTS USE WPS: POL-16.		
3601-B551	V-202 ACID GAS RUN DOWN DRUM	0	04-06-30	CK		PRELIMINARY						TEST WT.	DRAWN C.KIRKPATRICK CHECKED ENG. APP'L PROD. APP'L JOB NO. 3601 DATE 04-06-30 DATE DATE DATE SCALE 1:10 CUSTOMER/PROJECT/LOCATION BURLINGTON RESOURCES CANADA LTD. BRASSEY AMINE PLANT LSD: d-13-f/93-P-10 TITLE V-202 MISC. DETAILS ACID GAS RUN DOWN DRUM DRAWING NO. 3601-B551 REV. 0		
												SANDBLAST SEE DWG.#3601-B501			
												PRIMER SEE DWG.#3601-B501			
												PAINT SEE DWG.#3601-B501			