


Date Saved: 2010-08-11 2:25pm

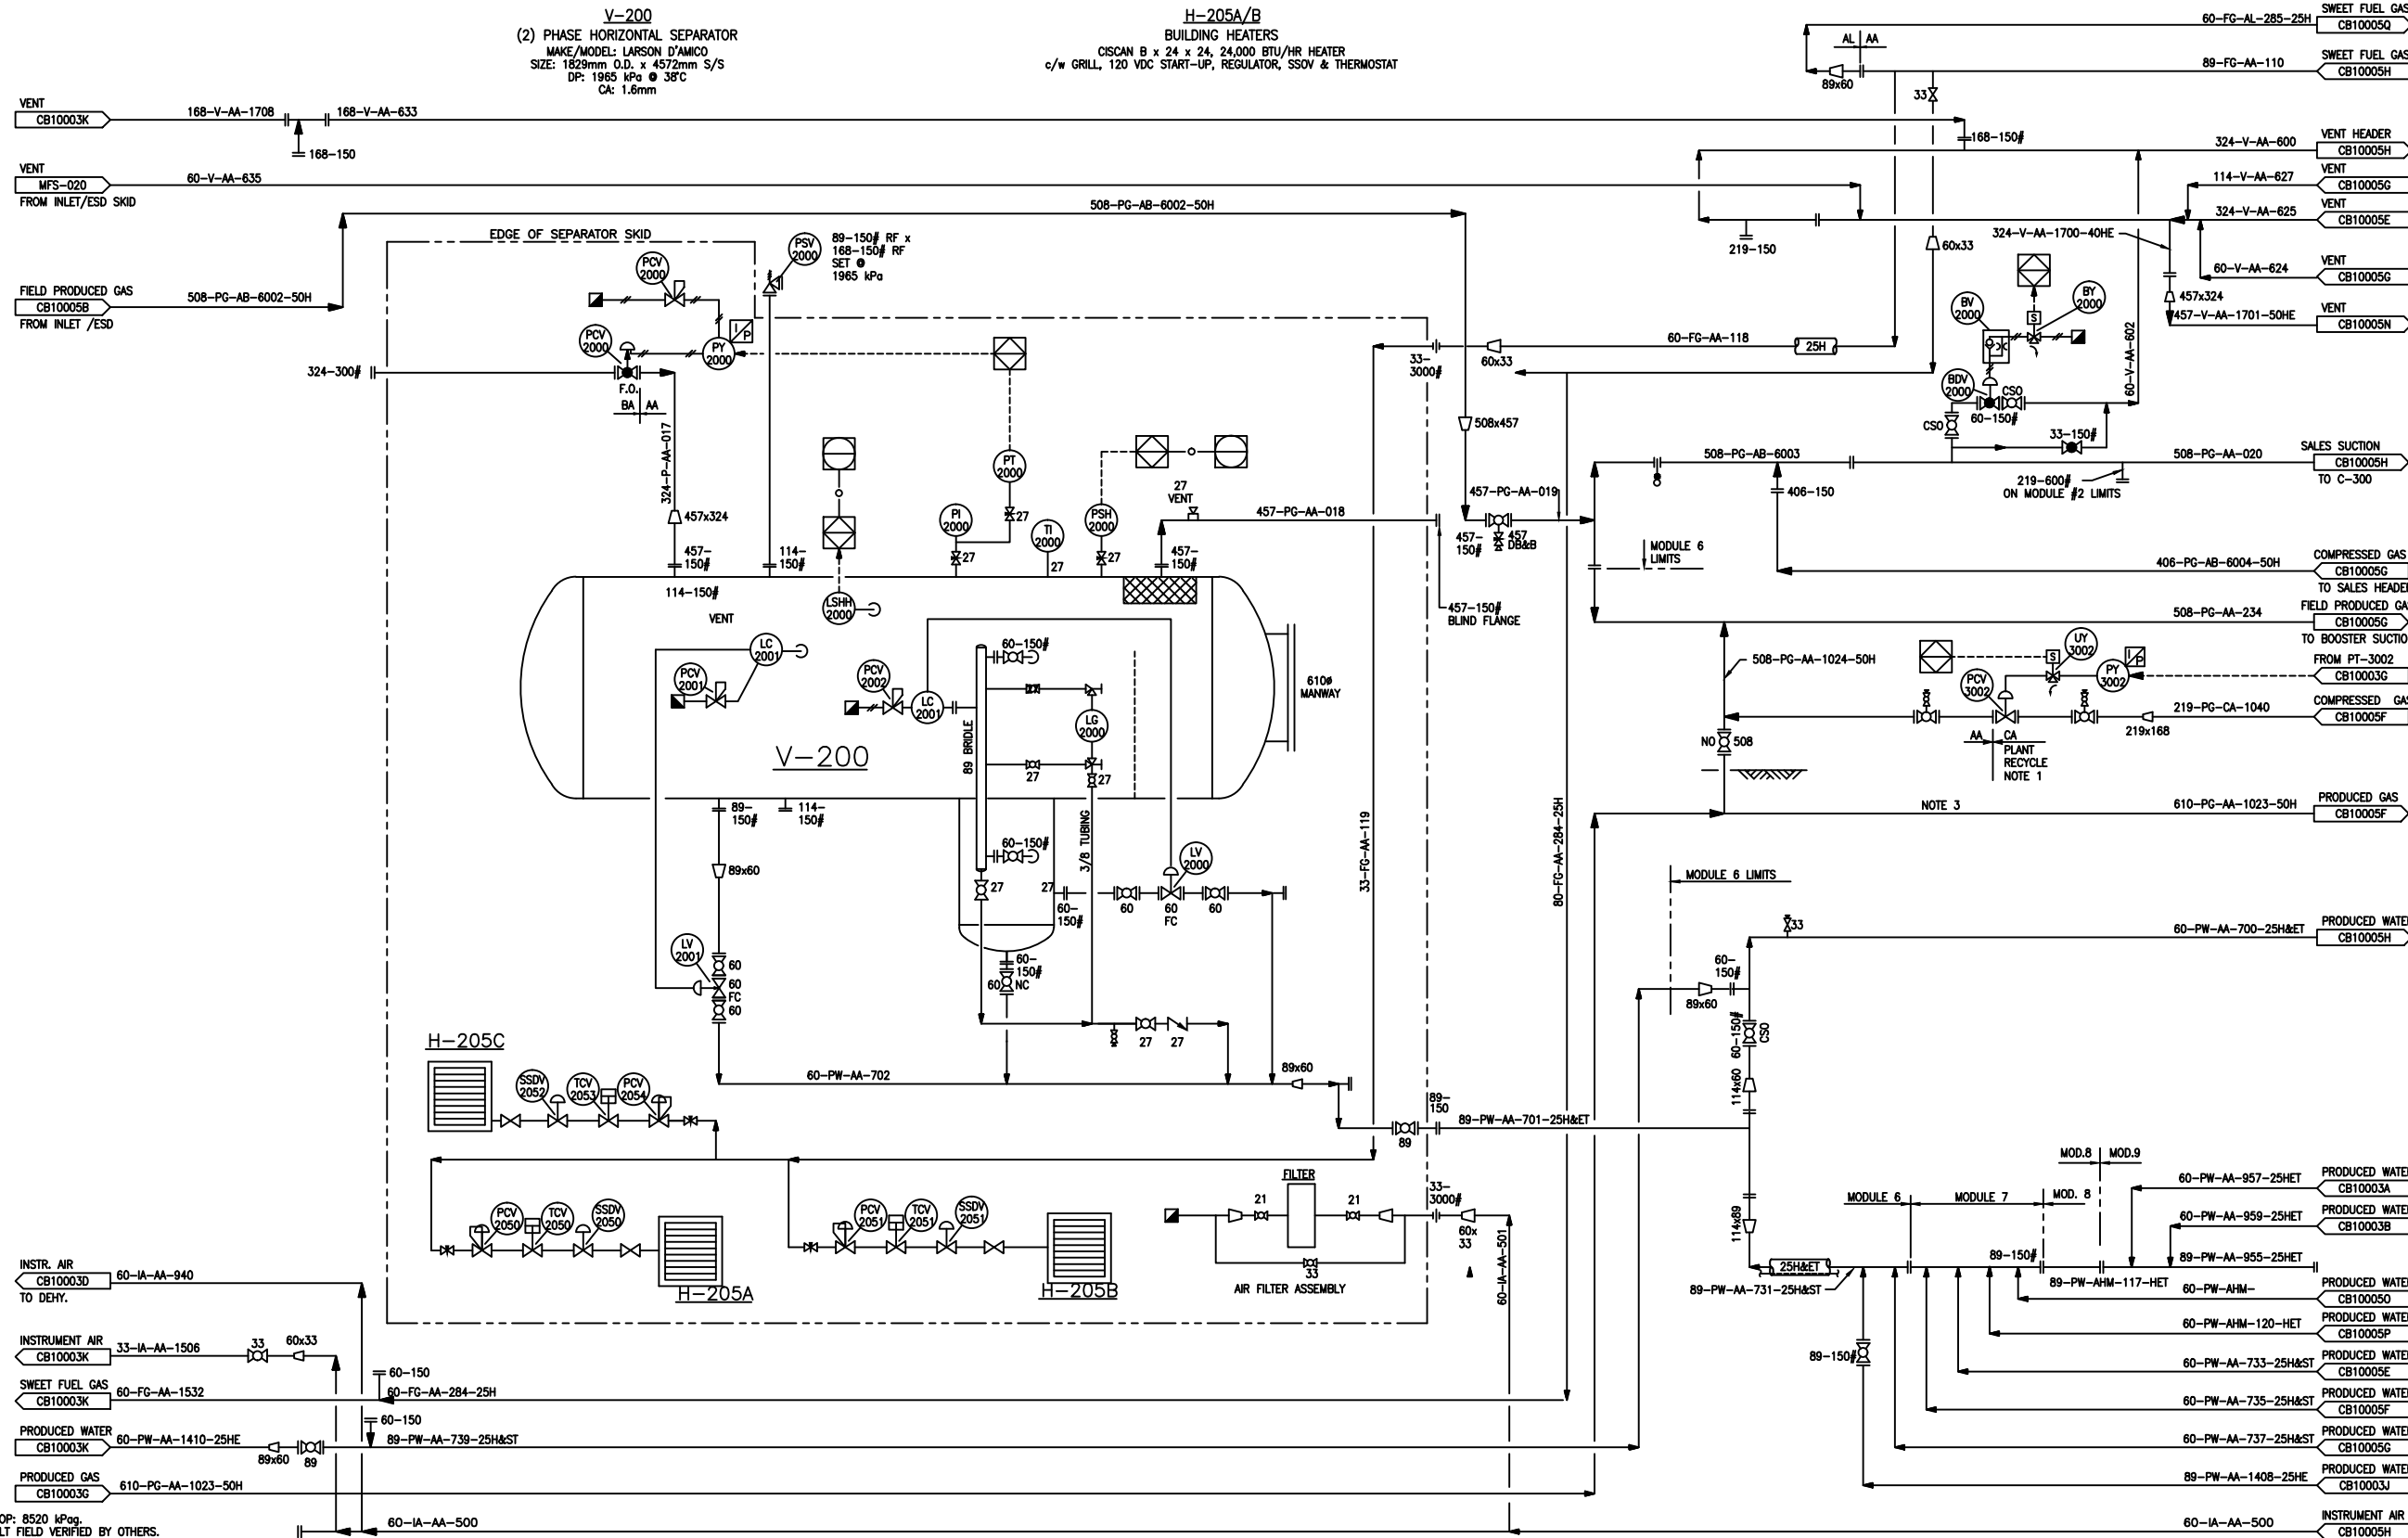

- NOTES:
1. PIPE MOP: 8520 kPag.
 2. AS-BUILT FIELD VERIFIED BY OTHERS.
 3. CAPS MOVED TO DRAWING CB10005F FOR CLARITY.

REFERENCE DRAWINGS	DWG. NO.
-	-
-	-
-	-
-	-
-	-
-	-
-	-

NO.	DATE	PROJECT DESCRIPTION	PROJ.	AFE	EPCM Co.	EPCM No.	APPD.
14	2006-12-12	ISSUED FOR CONSTRUCTION, 2007 PLANT RECONFIGURATION	2312	-	SEGMENT	2312	-
15	2007-03-09	AS BUILT	2312	-	SEGMENT	2312	-
16	2011-05-02	CLAWR - 2010 CARIBOU LAKE NORTH CS 8520 kPag REBATE	-	-	GRB ENG.	9044.33	-
17	2011-05-13	EQUIPMENT ISOLATION	-	-	GRB ENG.	9044.34	-
18	2012-04-17	CARIBOU LAKE NORTH DEHY #2 ISOLATION	-	-	GRB ENG.	9044.36	-
19	2013-09-04	CLH-SALES SUCTION LIQUID CARRYOVER	-	-	GENVAR	1311701000	-

CAUTION : READ BEFORE EXCAVATION
ALL EXCAVATIONS MUST BE CARRIED OUT AS PER
Cenovus Energy Inc. "GROUND DISTURBANCE PRACTICES"

ISSUE STAGE	DATE	BY	CHKD.	APPD.
Prelim. (A)	-	-	-	-
Bld (B)	-	-	-	-
Contr. (C)	2013-09-13	SN	NK	ED
As built (I)	-	-	-	-
-	-	-	-	-
-	-	-	-	-
-	-	-	-	-

REV. NO.	FORMAT	DATE	BY	CHKD.	APPD.
1	1	2013-09-13	SN	NK	ED
2	1	2013-09-13	SN	NK	ED
3	1	2013-09-13	SN	NK	ED
4	1	2013-09-13	SN	NK	ED
5	1	2013-09-13	SN	NK	ED
6	1	2013-09-13	SN	NK	ED
7	1	2013-09-13	SN	NK	ED
8	1	2013-09-13	SN	NK	ED
9	1	2013-09-13	SN	NK	ED
10	1	2013-09-13	SN	NK	ED

PERMIT STAMP	ENGINEER'S STAMP
-	-
-	-
NORTH COMPRESSOR STATION	
11-08-070-04 W4M	
COMPRESSOR STATION	
11-08-070-04 W4M	
NTS (A1 Size)	
GENVAR INC.	
PIPING AND INSTRUMENTATION DIAGRAM	
SEPARATOR	
CARIBOU	
CLASS FILE NO.	
A CB10005D	

2016-07-31 2051 FILE: Z:\CONSEXTRACT\CURRENT\CARIBOU\CB10005D.DWG CLANGEM PLOTTED BY JETHA, RAHIM S.