


This print and information portrayed there-on must not be reproduced or extracted without the permission of TECHSKIL LTD.

AREA LIMIT E.O+70.000

AREA LIMIT E.O+92.000

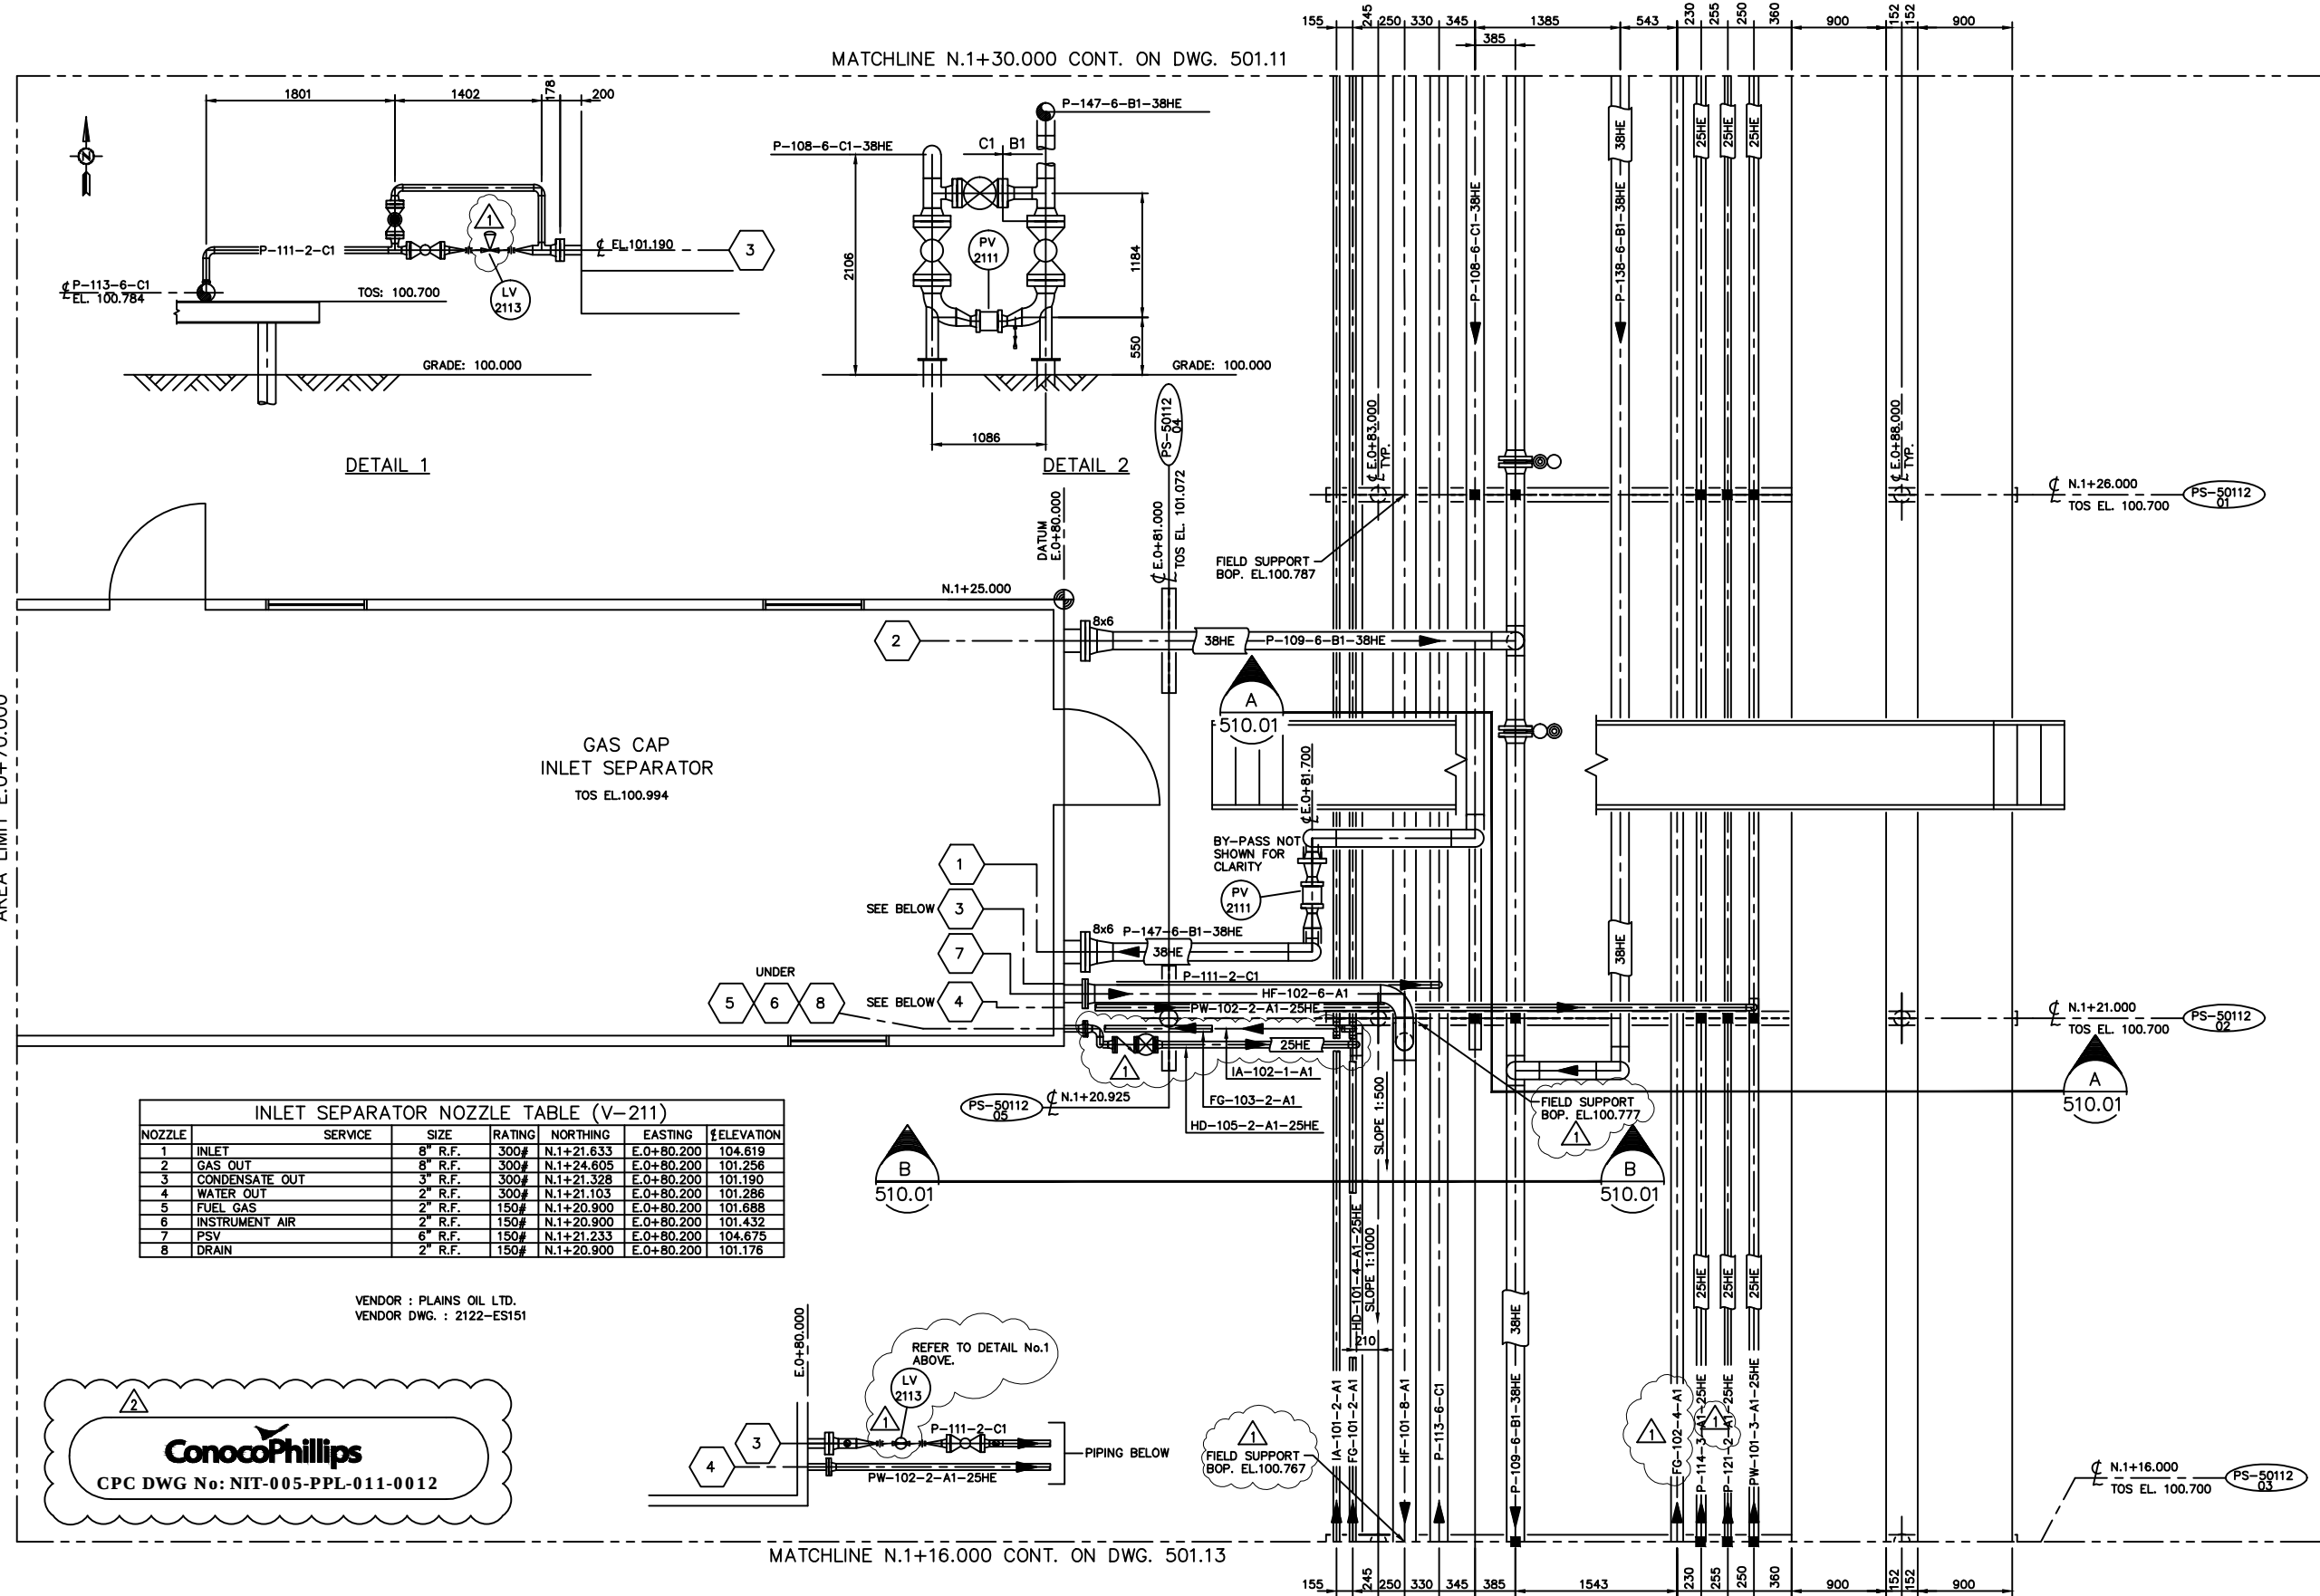

REFERENCE DRAWINGS	DWG No

2	08.04.30	ADDED CPC DRAWING NUMBER	CDL
1	98.11.10	REVISED AS NOTED	BS
0	98.10.23	ISSUED FOR CONSTRUCTION	TNT
REV	DATE	REVISION DESCRIPTION	BY

ENGINEER	G.EVERETT		
APPROVAL	G.EVERETT		
CHECKER	C.WIGHT		
DRAWN	D.HARLAND		
DATE	98.09.15		
SCALE:	1:30	APPROVED	DATE

LICENCE AND PERMIT

NITON PRODUCTION FACILITIES INLET SEPARATOR PIPING PLAN LSD 8-30-55-12-W5M				
TECHSKIL TECHNOLOGY & DRAFTING		PLANT No	DRAWING No.	REV
833 - 34 AVENUE S.E. CALGARY ALBERTA T2G 4Y9		P35	501.12	2

DB1-NIT-44-GA-00-0013-001