
 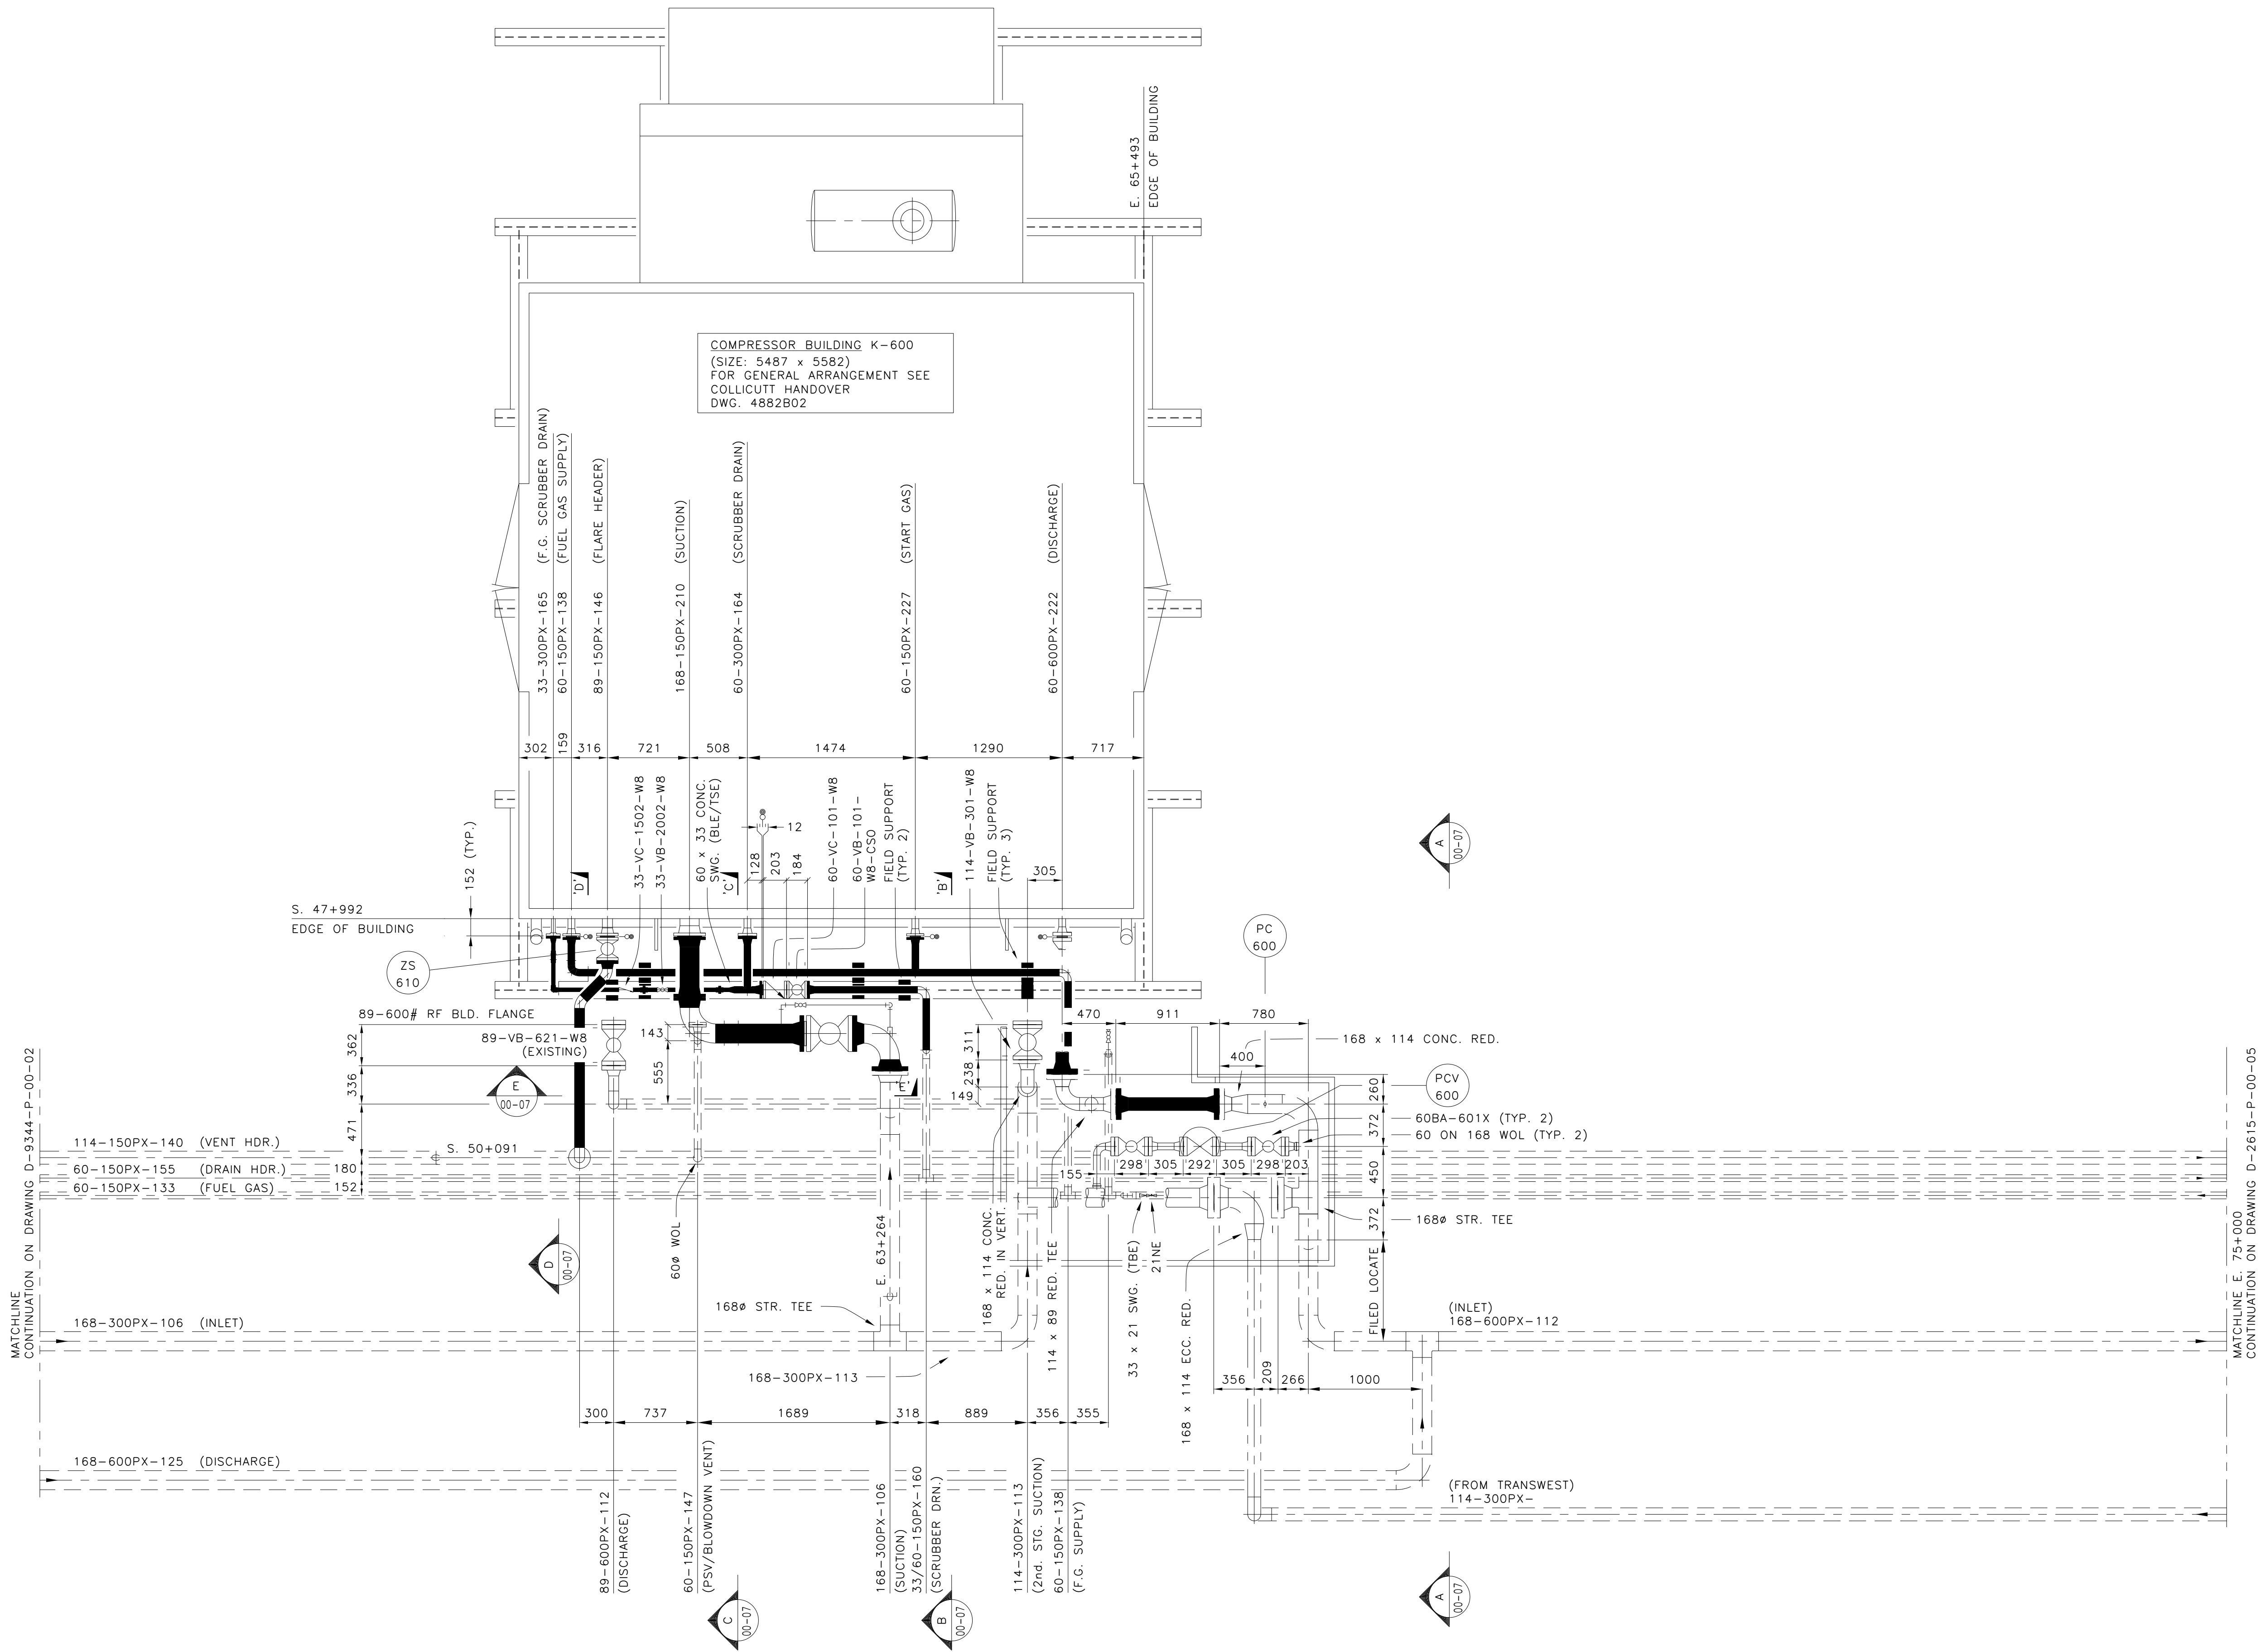




.						
.						
.						
.						
.						
8	POST CONSTRUCTION ISSUE	23154	L. ST.	03.07.17		
7	REDRAWN ON CAD & MODIFIED FOR NEW K-610 COMPRESSOR	23154	FJ	02.12.20	RD	03.02.06
6	AS BUILT		CR	95.12.29		
5	114Ø K-600 SUCTION ADDED	51202	JB	95.9.13		
NO.	REVISION	PROJ. No.	BY	DATE	CHK.	DATE

PERMIT STAMP:

GENERAL NOTES:

- "POST CONSTRUCTION DRAWINGS" ARE GENERATED FROM CONSTRUCTION CHANGE INFORMATION FORWARDED TO BOWER DAMBERGER ROLSETH ENGINEERING LTD. BY THE OWNER'S FIELD SUPERVISORS AND/OR FIELD CONTRACTORS. ANY CHANGES NOT DOCUMENTED WILL NOT APPEAR ON THE DRAWINGS AND THEREFORE THE DRAWING MAY NOT BE AN ACCURATE REPRESENTATION OF THE CONSTRUCTED FACILITY.
- PRIOR TO THE COMMENCEMENT OF ANY CONSTRUCTION AND/OR EXCAVATION IT SHALL BE THE RESPONSIBILITY OF THE OWNER'S REPRESENTATIVE TO VERIFY THE LOCATION AND EXISTENCE OF ANY PIPING, ELECTRICAL, EQUIPMENT OR BUILDINGS.
- ANY REVISIONS MADE TO EXISTING EQUIPMENT, PIPING OR ELECTRICAL ON A FACILITY NOT DESIGNED BY BDR ENG. LTD. IS ONLY SHOWN AS A REPRESENTATION OF WHAT EXISTS AND MUST BE VERIFIED BY THE OWNER.

	BY	DATE
DRN.	F. JOSEPH	88.01.12
CHK.	W2	88.01.23
APP'D.		
L.S.D.	14-10-62-04	W4M

bdr
Bower Damberger Rolseth
Engineering Ltd.

HUSKY OIL OPERATIONS LIMITED

FORT KENT COMPRESSOR STATION ADDITION
COMPRESSOR BUILDING K-600 AREA PIPING PLAN

SCALE	DRAWING NUMBER	REV
1:30	D-7225-P-00-03	8