


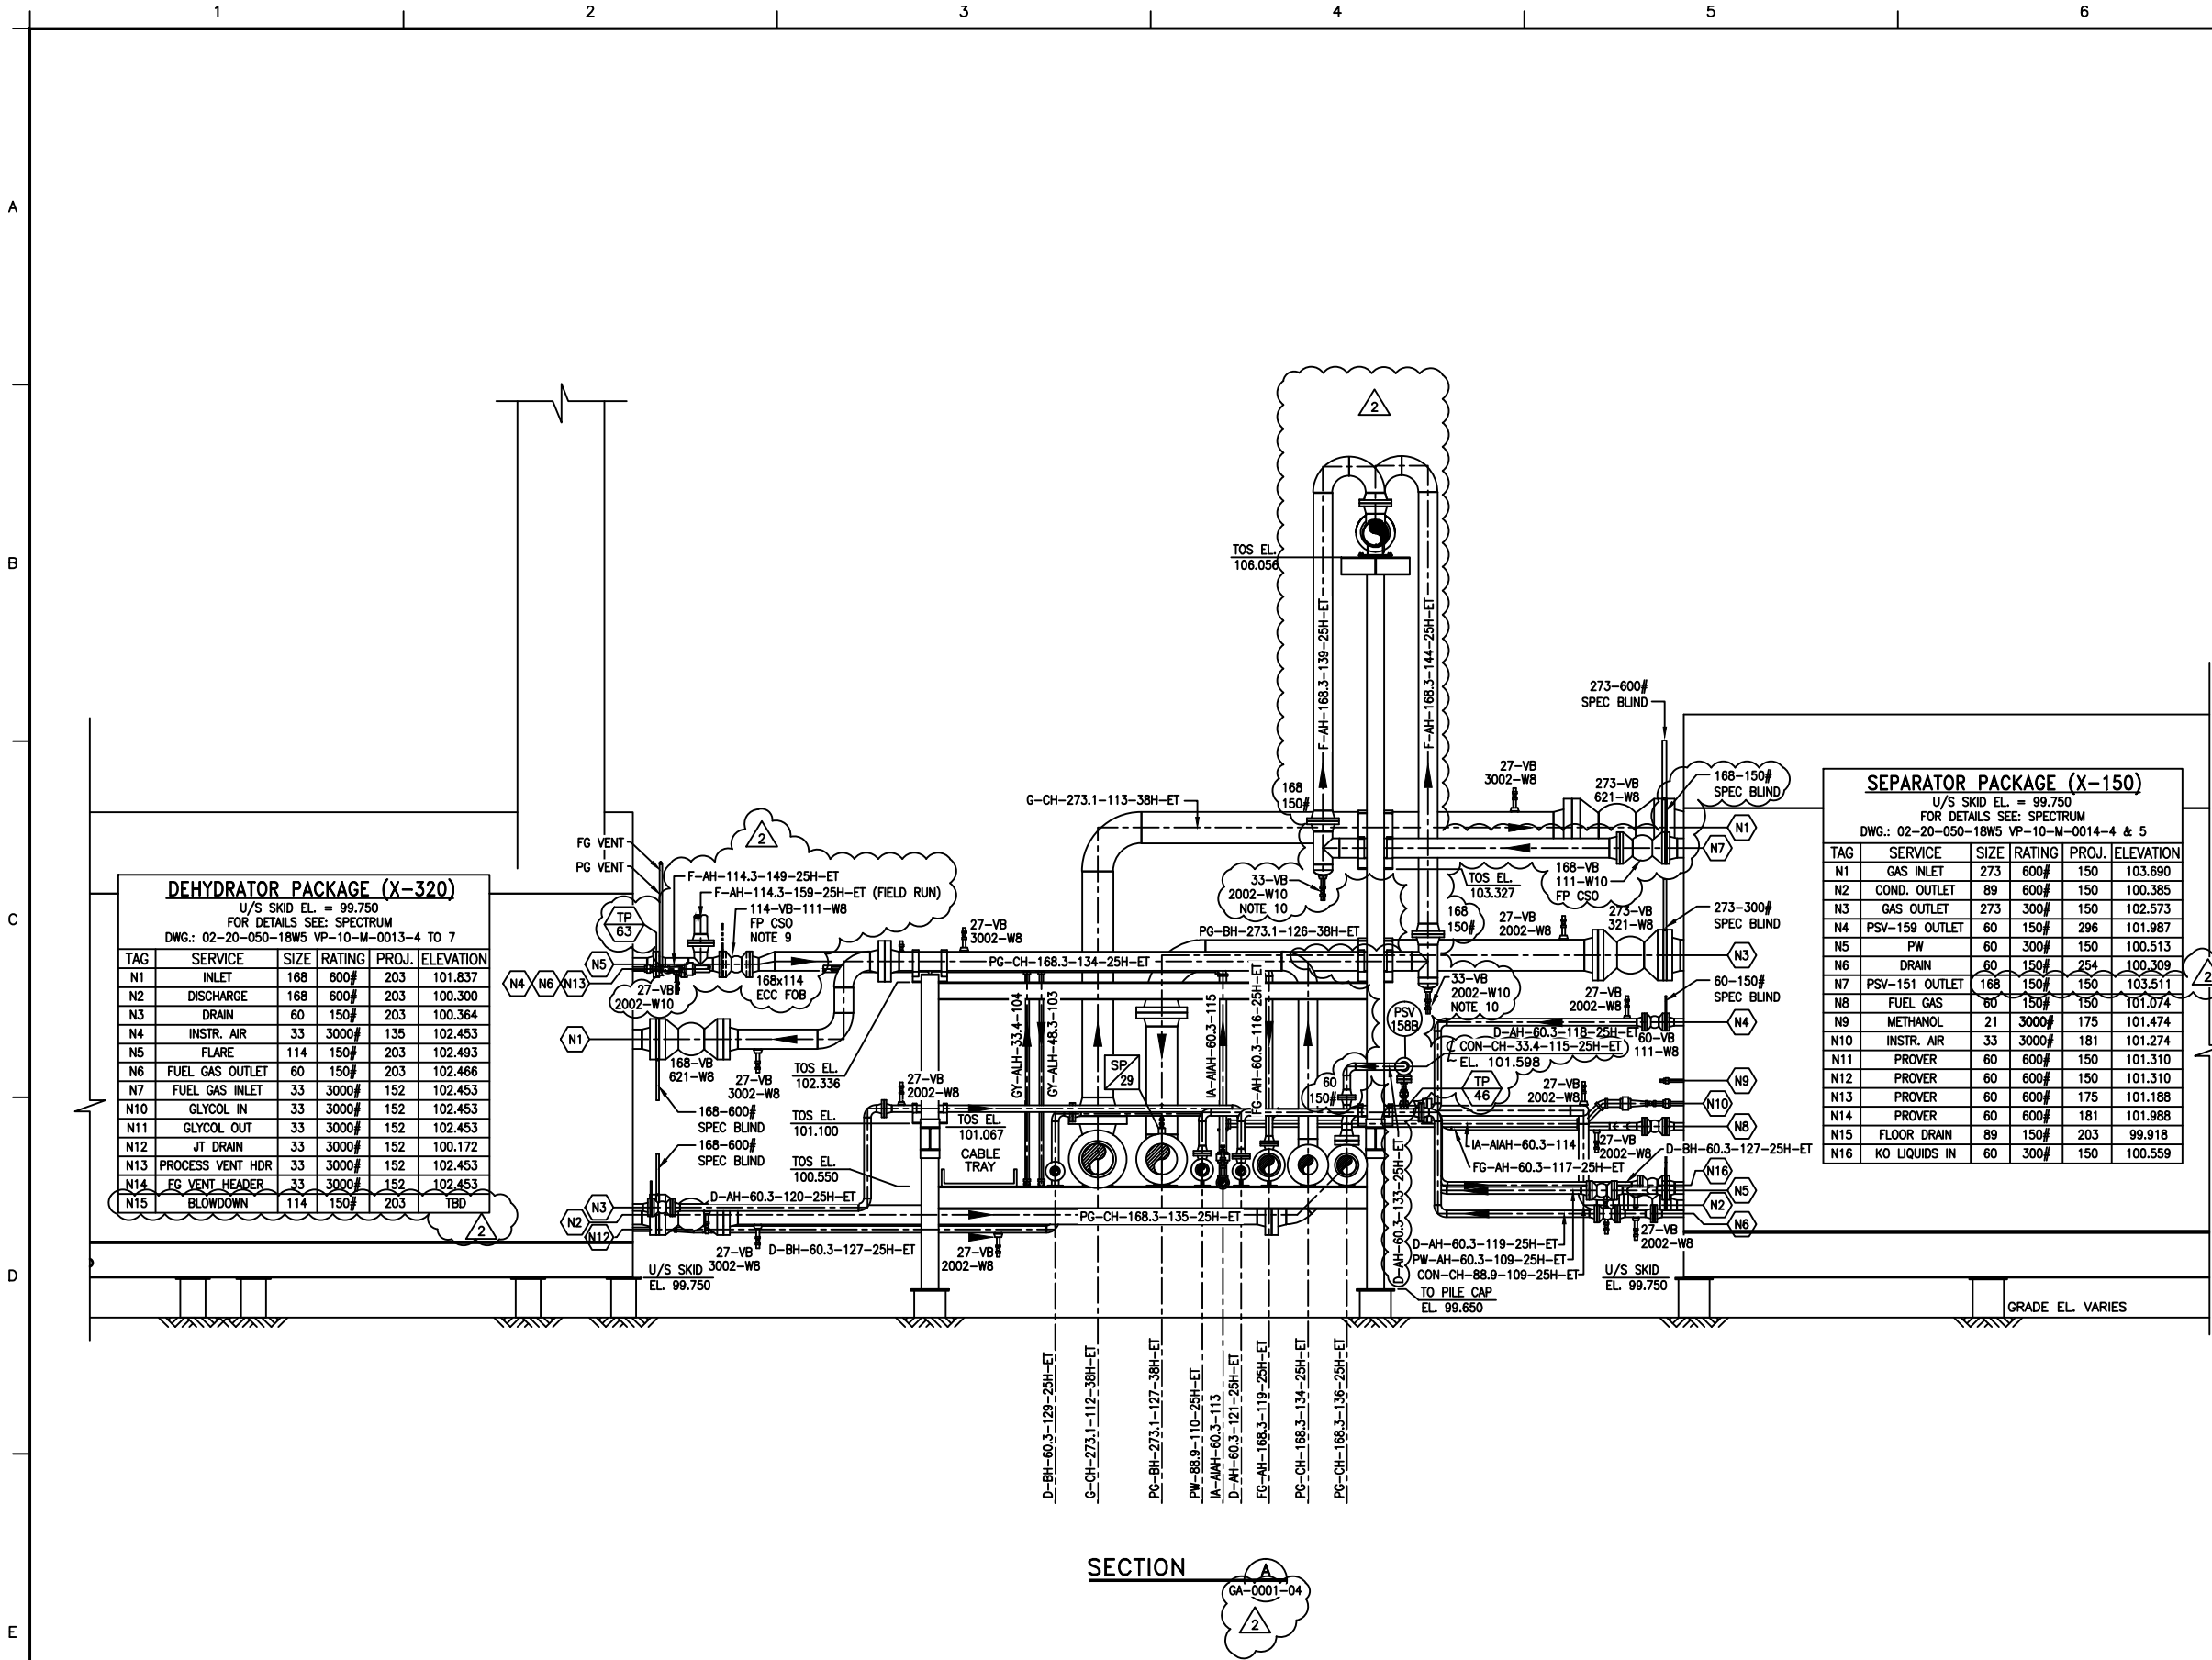

NOTES

- TRACE & OR INSULATE BURIED LINES TO BOTTOM OF TRENCH.
- ALL PROCESS & INSTRUMENT VENTS SHALL BE AT LEAST 500mm FROM ANY ELECTRICAL CONNECTION OR OUTLET.
- ▲ DENOTES VENDOR SUPPLIED ITEMS.
- FOR PIPE SHOES AND OTHER LINE SUPPORT DETAILS (eg. S24/G1) SEE STANDARD DRAWINGS 0100-000-STD-01.00.
- FOR PIPE SUPPORT DETAILS (eg. PS-AA01) SEE STRUCTURAL PIPE SUPPORT DRAWING 02-20-050-18W5 PS-10-S-0003-01 TO 12.
- CONTRACTOR TO PROVIDE & LOCATE 27mm VENTS & DRAINS AS REQUIRED FOR HYDROTESTING.
- WHERE SPECIFIED INSULATE ALL PIPING, VALVES & FLANGES WITH SPECIFIED THICKNESS FIBERGLASS W/ALUMINUM CLADDING A/G & POLYURETHANE WITH TAPE U/G.
- GRADE ELEVATION VARIES, REFER TO GRADING PLAN FOR SITE ELEVATIONS DWG. 02-20-050-18W5 ER-10-C-0001-1.
- 114-VB-111-WB VALVE AND 114-150# SPEC BLIND ARE RE-USED.
- AN OPERATING PROCEDURE NEEDS TO BE IN PLACE TO ENSURE THAT NO ACCUMULATED LIQUID IS PRESENT IN DRIP LEG AND THE LINE IS TO BE DRAINED WHEN REQUIRED.

ENGINEERING COMPANY PERMIT STAMP		REGISTERED PROFESSIONAL ENGINEER STAMP	
6			
5			
4			
3			
2			
1			
REF	DRAWING NUMBER	DRAWING TITLE	
REFERENCE DRAWINGS			
2	2017/03/10	IFC FOR EWR 22510 STANTEC 110902423	CML
1	2014/12/12	IFC FOR EWR 19227 EXCELSIOR 4178HUS	TMD KAB AM SA
REV	DATE	DESCRIPTION	BY CHK ENG APR
REVISION HISTORY			
Husky Oil Operations Limited			
RAVEN CREEK 02-20-050-18W5 COMP STN			
TITLE SEPARATOR (X-150) & DEHYDRATOR (X-320) AREA SECTION VIEW "A"			
SURFACE LOCATION		02-20-050-18 W5M	
ALTERNATE DWG NUMBER		GA-10-M-0004-1	REV NO
HUSKY DWG NUMBER		02-20-050-18W5-GA-0002-01	2
VENDOR DWG NUMBER		SCALE	
AMU/FLOC NUMBER		W5-01-001-00007	1:30
DCN NO		PROJECT NO	EWR 22510