



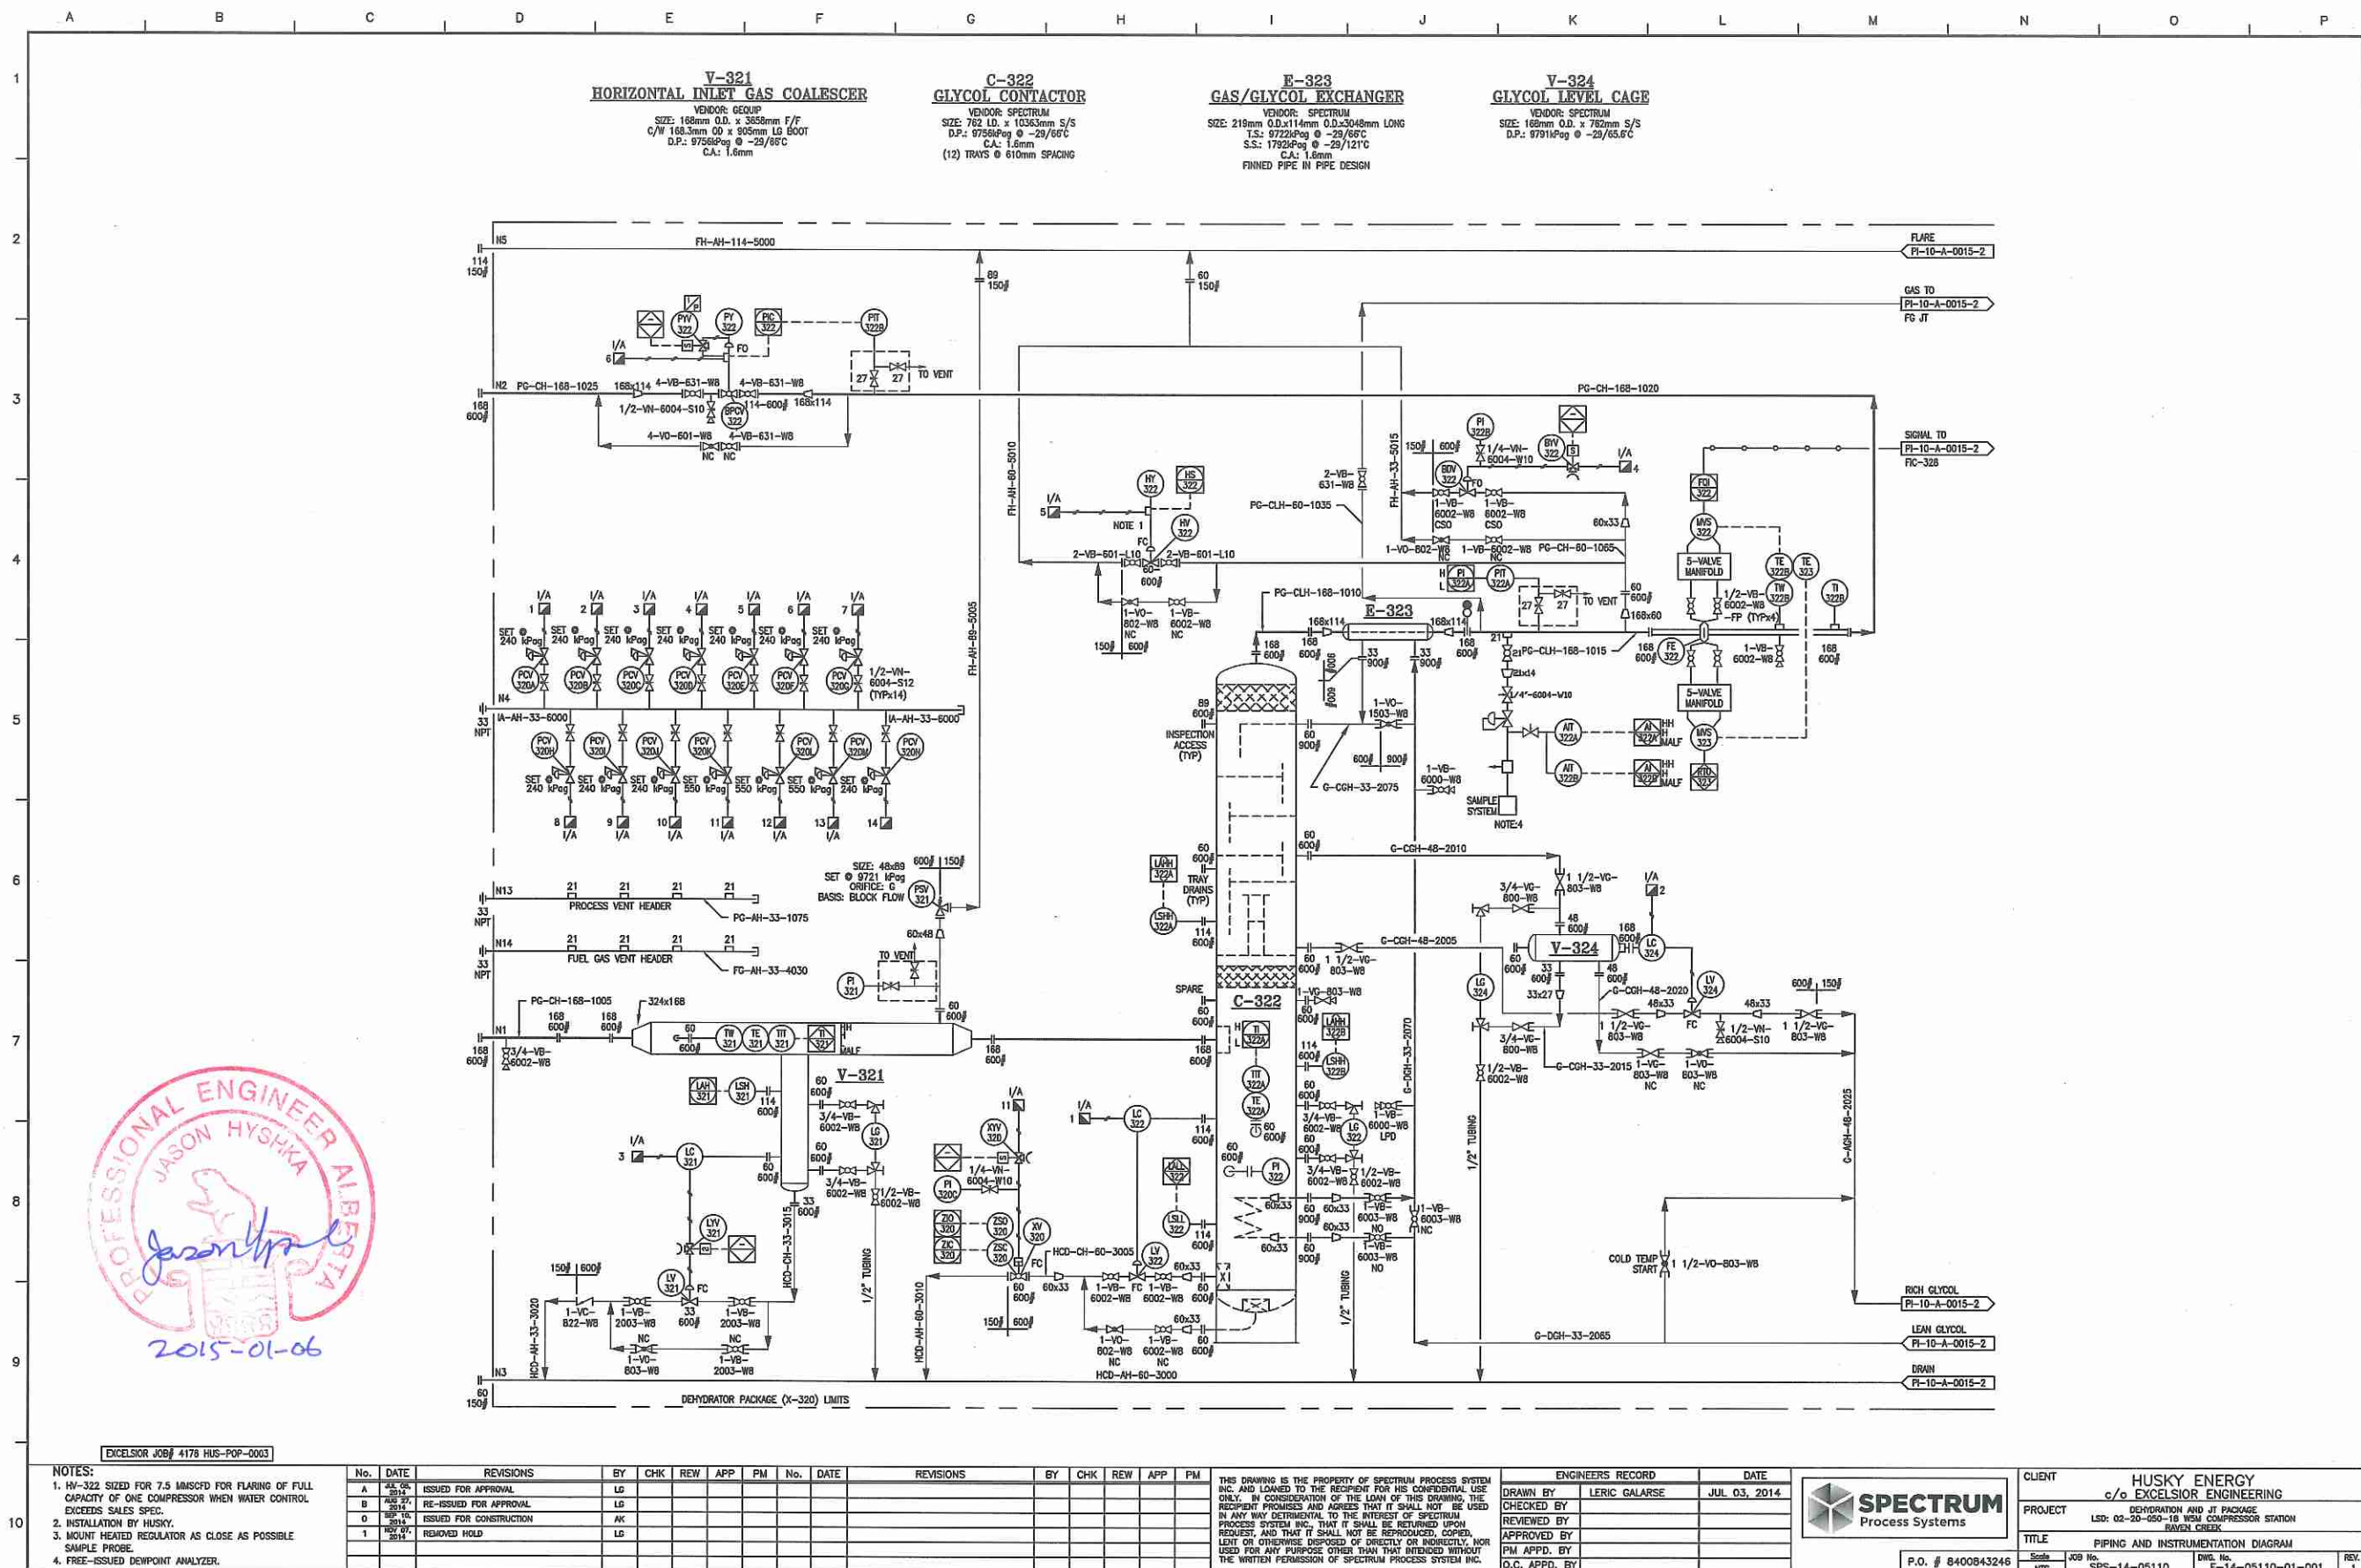

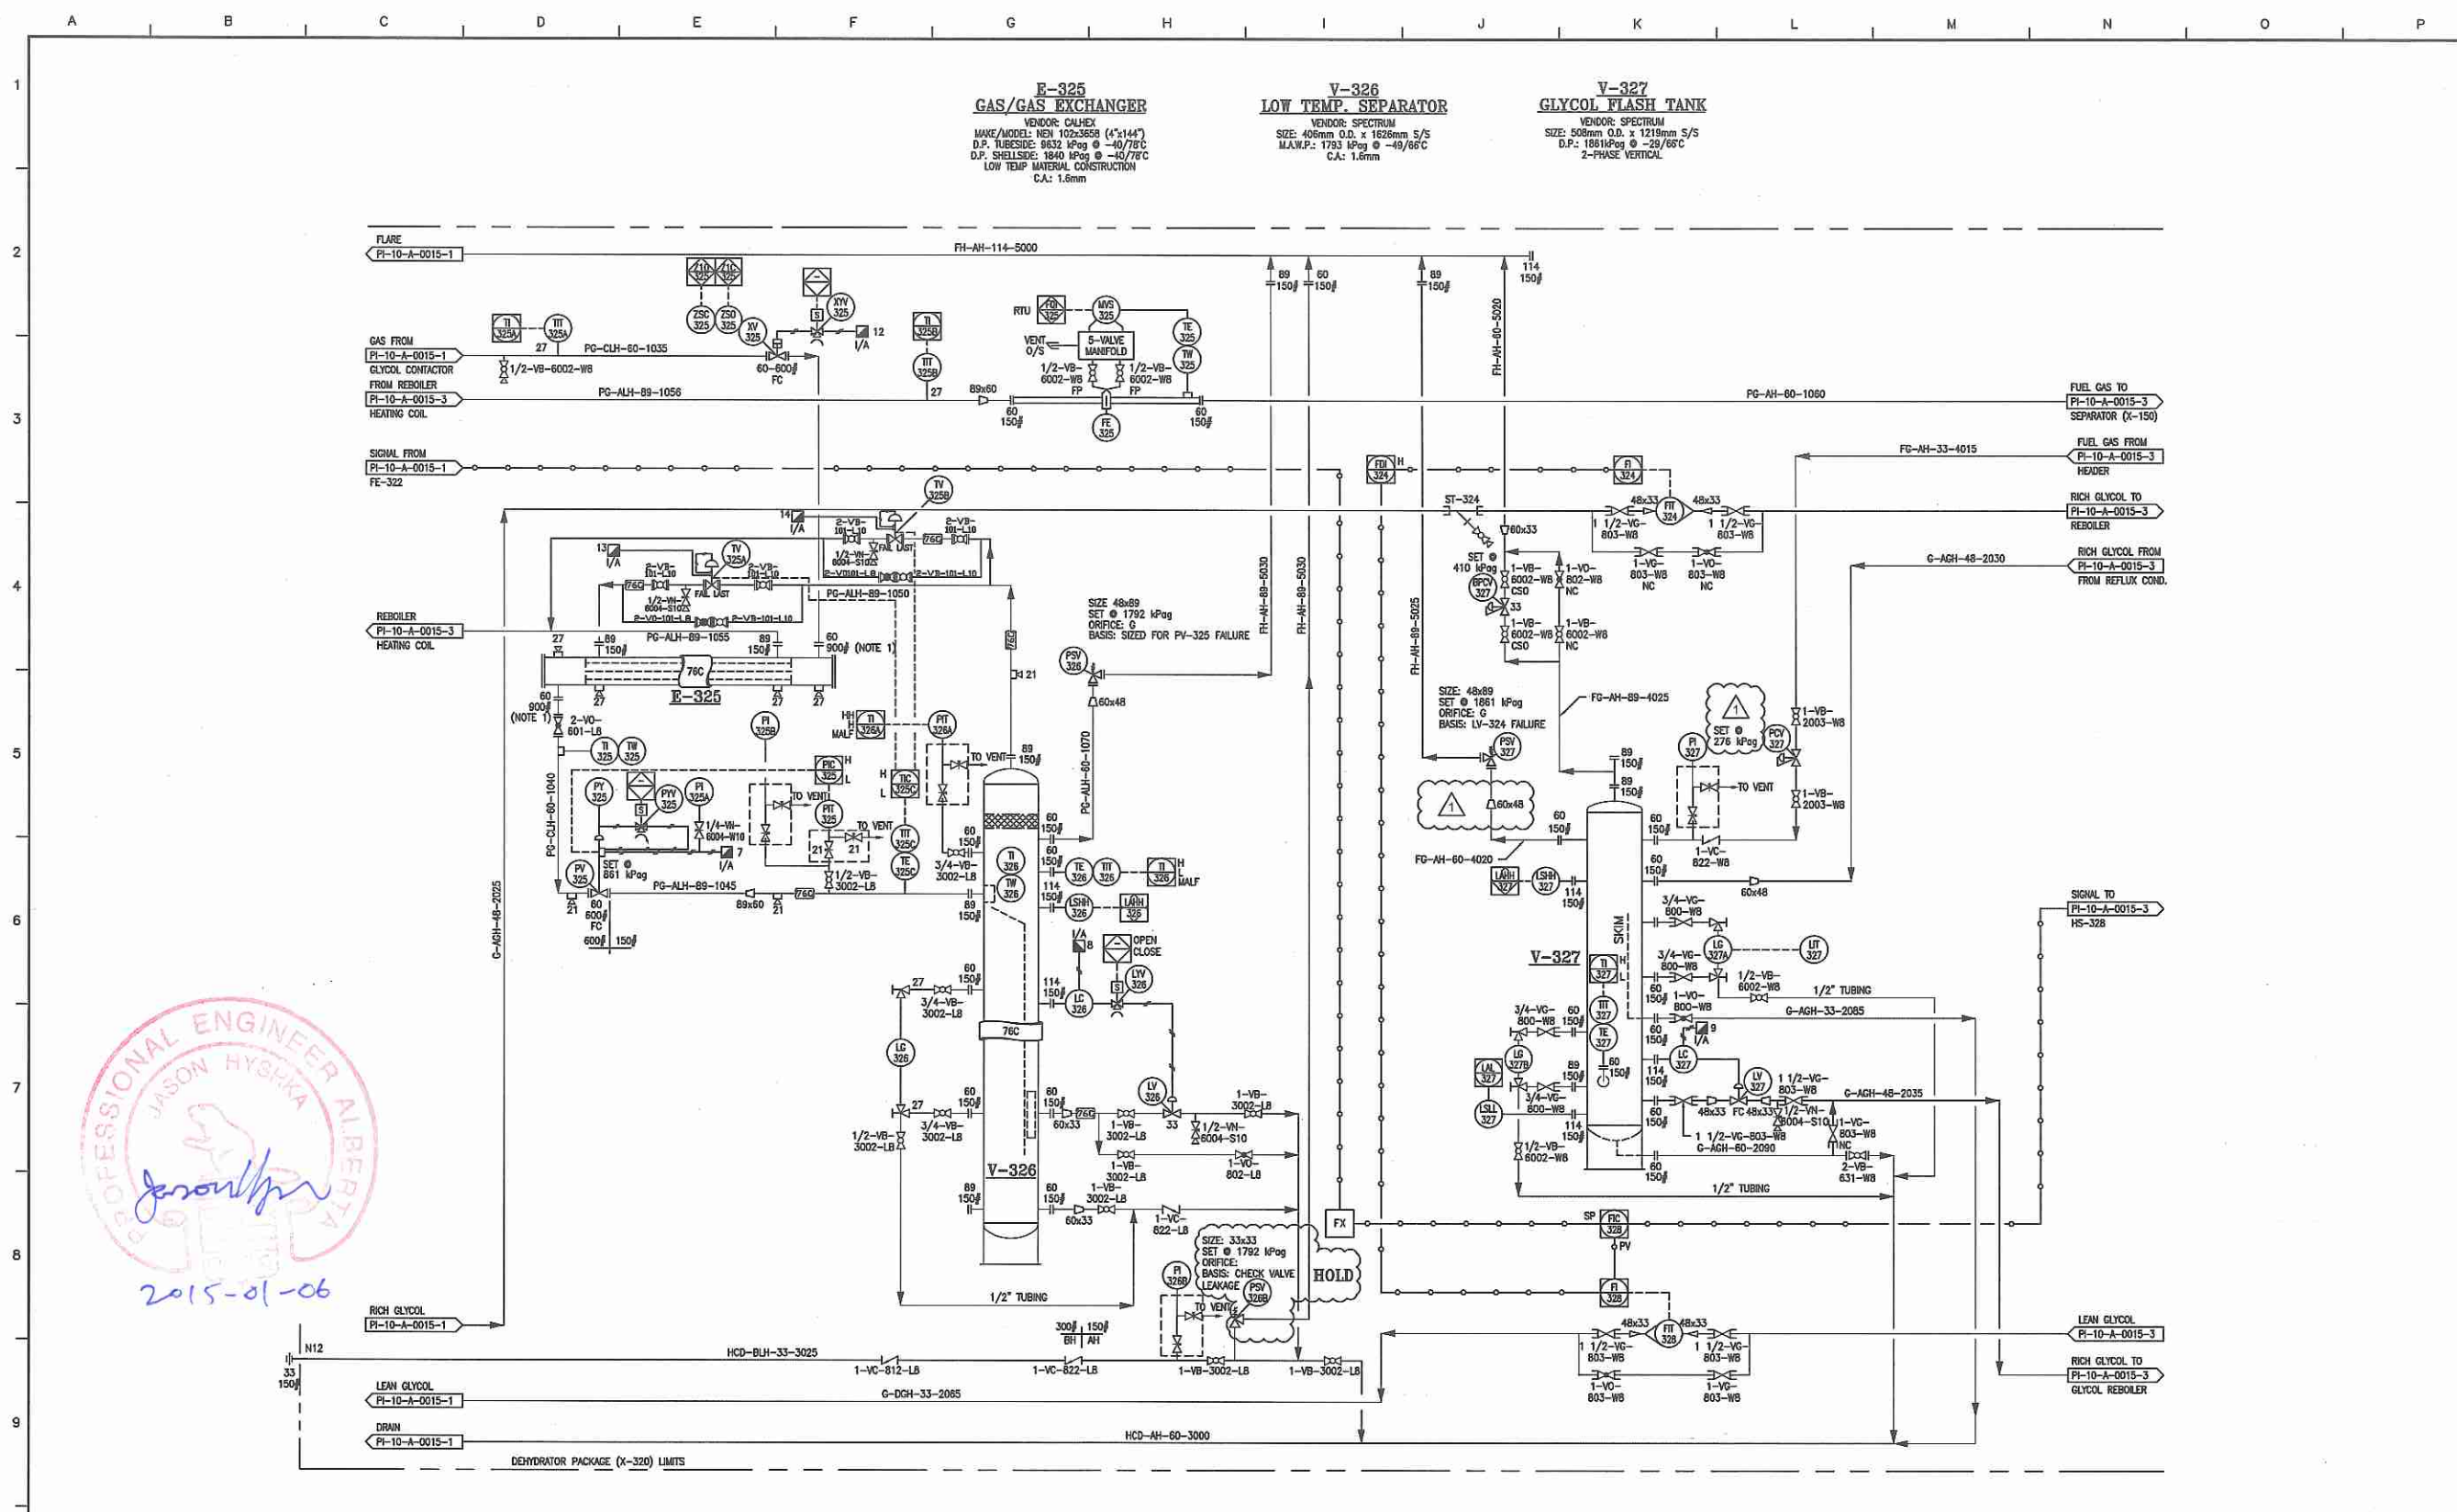


10

NOTE: 1. E-325 HAS 2"-900# RF FLANGES. PRESSURES STILL IN 600# RANGE (HUSKY CLH SPEC.)									
No.	DATE	REVISIONS	BY	CHK	REV	APP	PM	No.	DATE
A	17/04/2014	ISSUED FOR APPROVAL	LG						
B	27/04/2014	RE-ISSUED FOR APPROVAL	LG						
C	27/04/2014	ISSUED FOR CONSTRUCTION	AK						
D	27/04/2014	REMOVED HOLDS; ADDED HOLD ON PSV-320B, CON. REDUCER (PSV-327), REV'D PSV-327 SETTING	LG						
EXCELSIOR JOB# 4178 HUS-POP-0003									

THIS DRAWING IS THE PROPERTY OF SPECTRUM PROCESS SYSTEM INC. AND LOANED TO THE RECIPIENT FOR HIS CONFIDENTIAL USE ONLY. IN CONSIDERATION OF THE LOAN OF THIS DRAWING, THE RECIPIENT PROMISES AND AGREES THAT IT SHALL NOT BE USED IN ANY WAY DETRIMENTAL TO THE INTEREST OF SPECTRUM PROCESS SYSTEM INC. THAT IT SHALL BE RETURNED UPON REQUEST, AND THAT IT SHALL NOT BE REPRODUCED, COPIED, LENT OR OTHERWISE DISPOSED OF DIRECTLY OR INDIRECTLY, NOR USED FOR ANY PURPOSE OTHER THAN THAT INTENDED WITHOUT THE WRITTEN PERMISSION OF SPECTRUM PROCESS SYSTEM INC.									
ENGINEERS RECORD		DATE							
DRAWN BY		ADONIS KALAF		SEP 17, 2014					
CHECKED BY									
REVIEWED BY									
APPROVED BY									
PM APP'D. BY									
G.C. APP'D. BY									

CLIENT		HUSKY ENERGY	
		c/o EXCELSIOR ENGINEERING	
PROJECT		DEHYDRATION AND JT PACKAGE	
		LSD: 02-20-00-10 NEW COMPRESSOR STATION	
		BARREN CREEK	
TITLE		PIPING AND INSTRUMENTATION DIAGRAM	
P.O. # 8400843246		Sps-14-05110	
		F-14-05110-01-002	
		REV. 1	

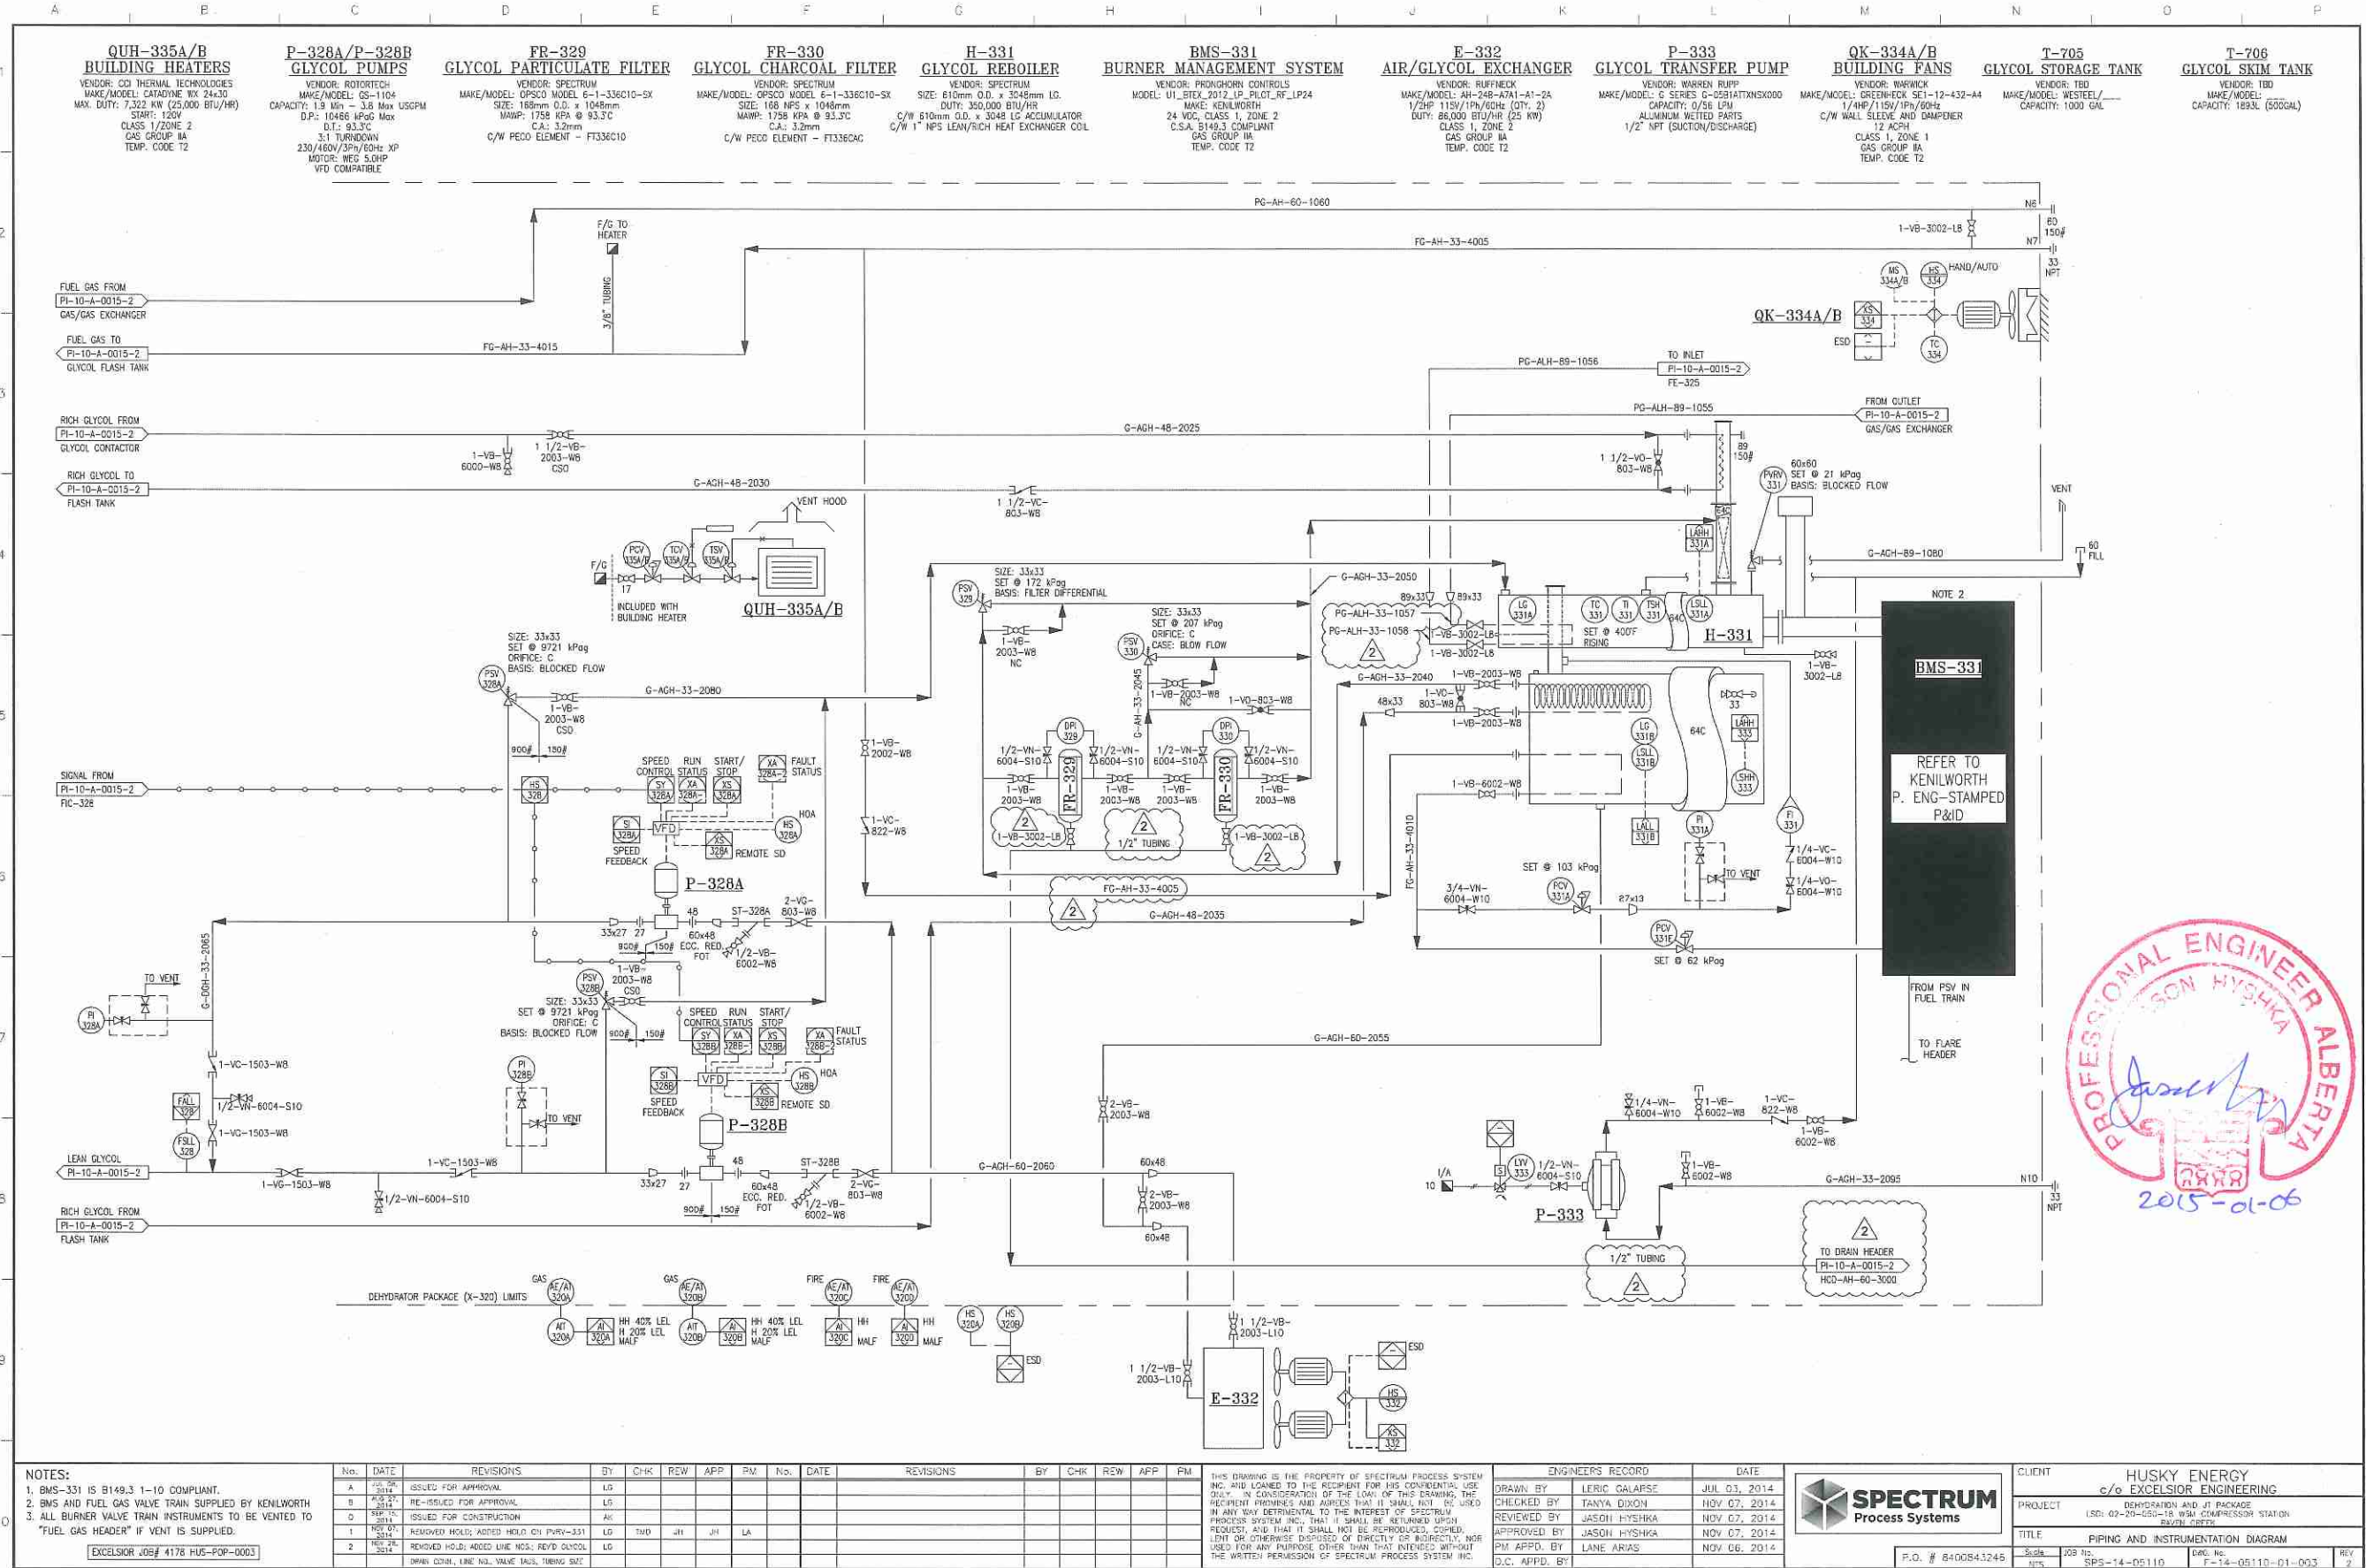

NOTES: 1. BMS-331 is B149.3 1-10 COMPLIANT. 2. BMS AND FUEL GAS VALVE TRAIN SUPPLIED BY KENILWORTH 3. ALL BURNER VALVE TRAIN INSTRUMENTS TO BE VENTED TO "FUEL GAS HEADER" IF VENT IS SUPPLIED. EXCELSIOR JOB# 4178 HUS-POP-0003	No.	DATE	REVISIONS	BY	CHK	REV	APP	PM	No.	DATE	REVISIONS	BY	CHK	REV	APP	PM	THIS DRAWING IS THE PROPERTY OF SPECTRUM PROCESS SYSTEM INC. AND LOANED TO THE RECIPIENT FOR HIS CONFIDENTIAL USE ONLY IN CONNECTION WITH THE WORK OF THIS DRAWING. THE RECIPIENT PROVIDES AND AGREES THAT IT SHALL NOT BE USED IN ANY WAY DETRIMENTAL TO THE INTEREST OF SPECTRUM PROCESS SYSTEM INC., THAT IT SHALL BE RETURNED UPON REQUEST, AND THAT IT SHALL NOT BE REPRODUCED, COPIED, LENT OR OTHERWISE DISPOSED OF DIRECTLY OR INDIRECTLY, NOR USED FOR ANY PURPOSE OTHER THAN THAT INTENDED WITHOUT THE WRITTEN PERMISSION OF SPECTRUM PROCESS SYSTEM INC.	
	A	10/03/2014	ISSUED FOR APPROVAL	LD														
	B	10/03/2014	RE-ISSUED FOR APPROVAL	LD														
	C	10/03/2014	ISSUED FOR CONSTRUCTION	AK														
	D	NOV 07, 2014	REMOVED HOLD; ADDED HOLD ON PURV-331	LD	THD	JH	JH	LA										
	E	NOV 07, 2014	REMOVED HOLD; ADDED LINE NO. VALVE TAGS, TUBING SIZE	LD														
ENGINEERS RECORD DRAWN BY LERIC GALARISE JUL 03, 2014 CHECKED BY TANYA DIXON NOV 07, 2014 REVIEWED BY JASON HYSHKA NOV 07, 2014 APPROVED BY JASON HYSHKA NOV 07, 2014 PM APPD. BY LANE ARIAS NOV 06, 2014 D.C. APPD. BY																		
F.O. # 8400543245																		
CLIENT HUSKY ENERGY c/o EXCELSIOR ENGINEERING PROJECT DEHYDRATION AND JT PACKAGE LSD: 02-20-050-18 WSA COMPRESSOR STATION BAYN DRETH TITLE PIPING AND INSTRUMENTATION DIAGRAM Scale 20% JOB NO. SPS-14-05110 DATE F-14-05110-01-003 REV 2																		