


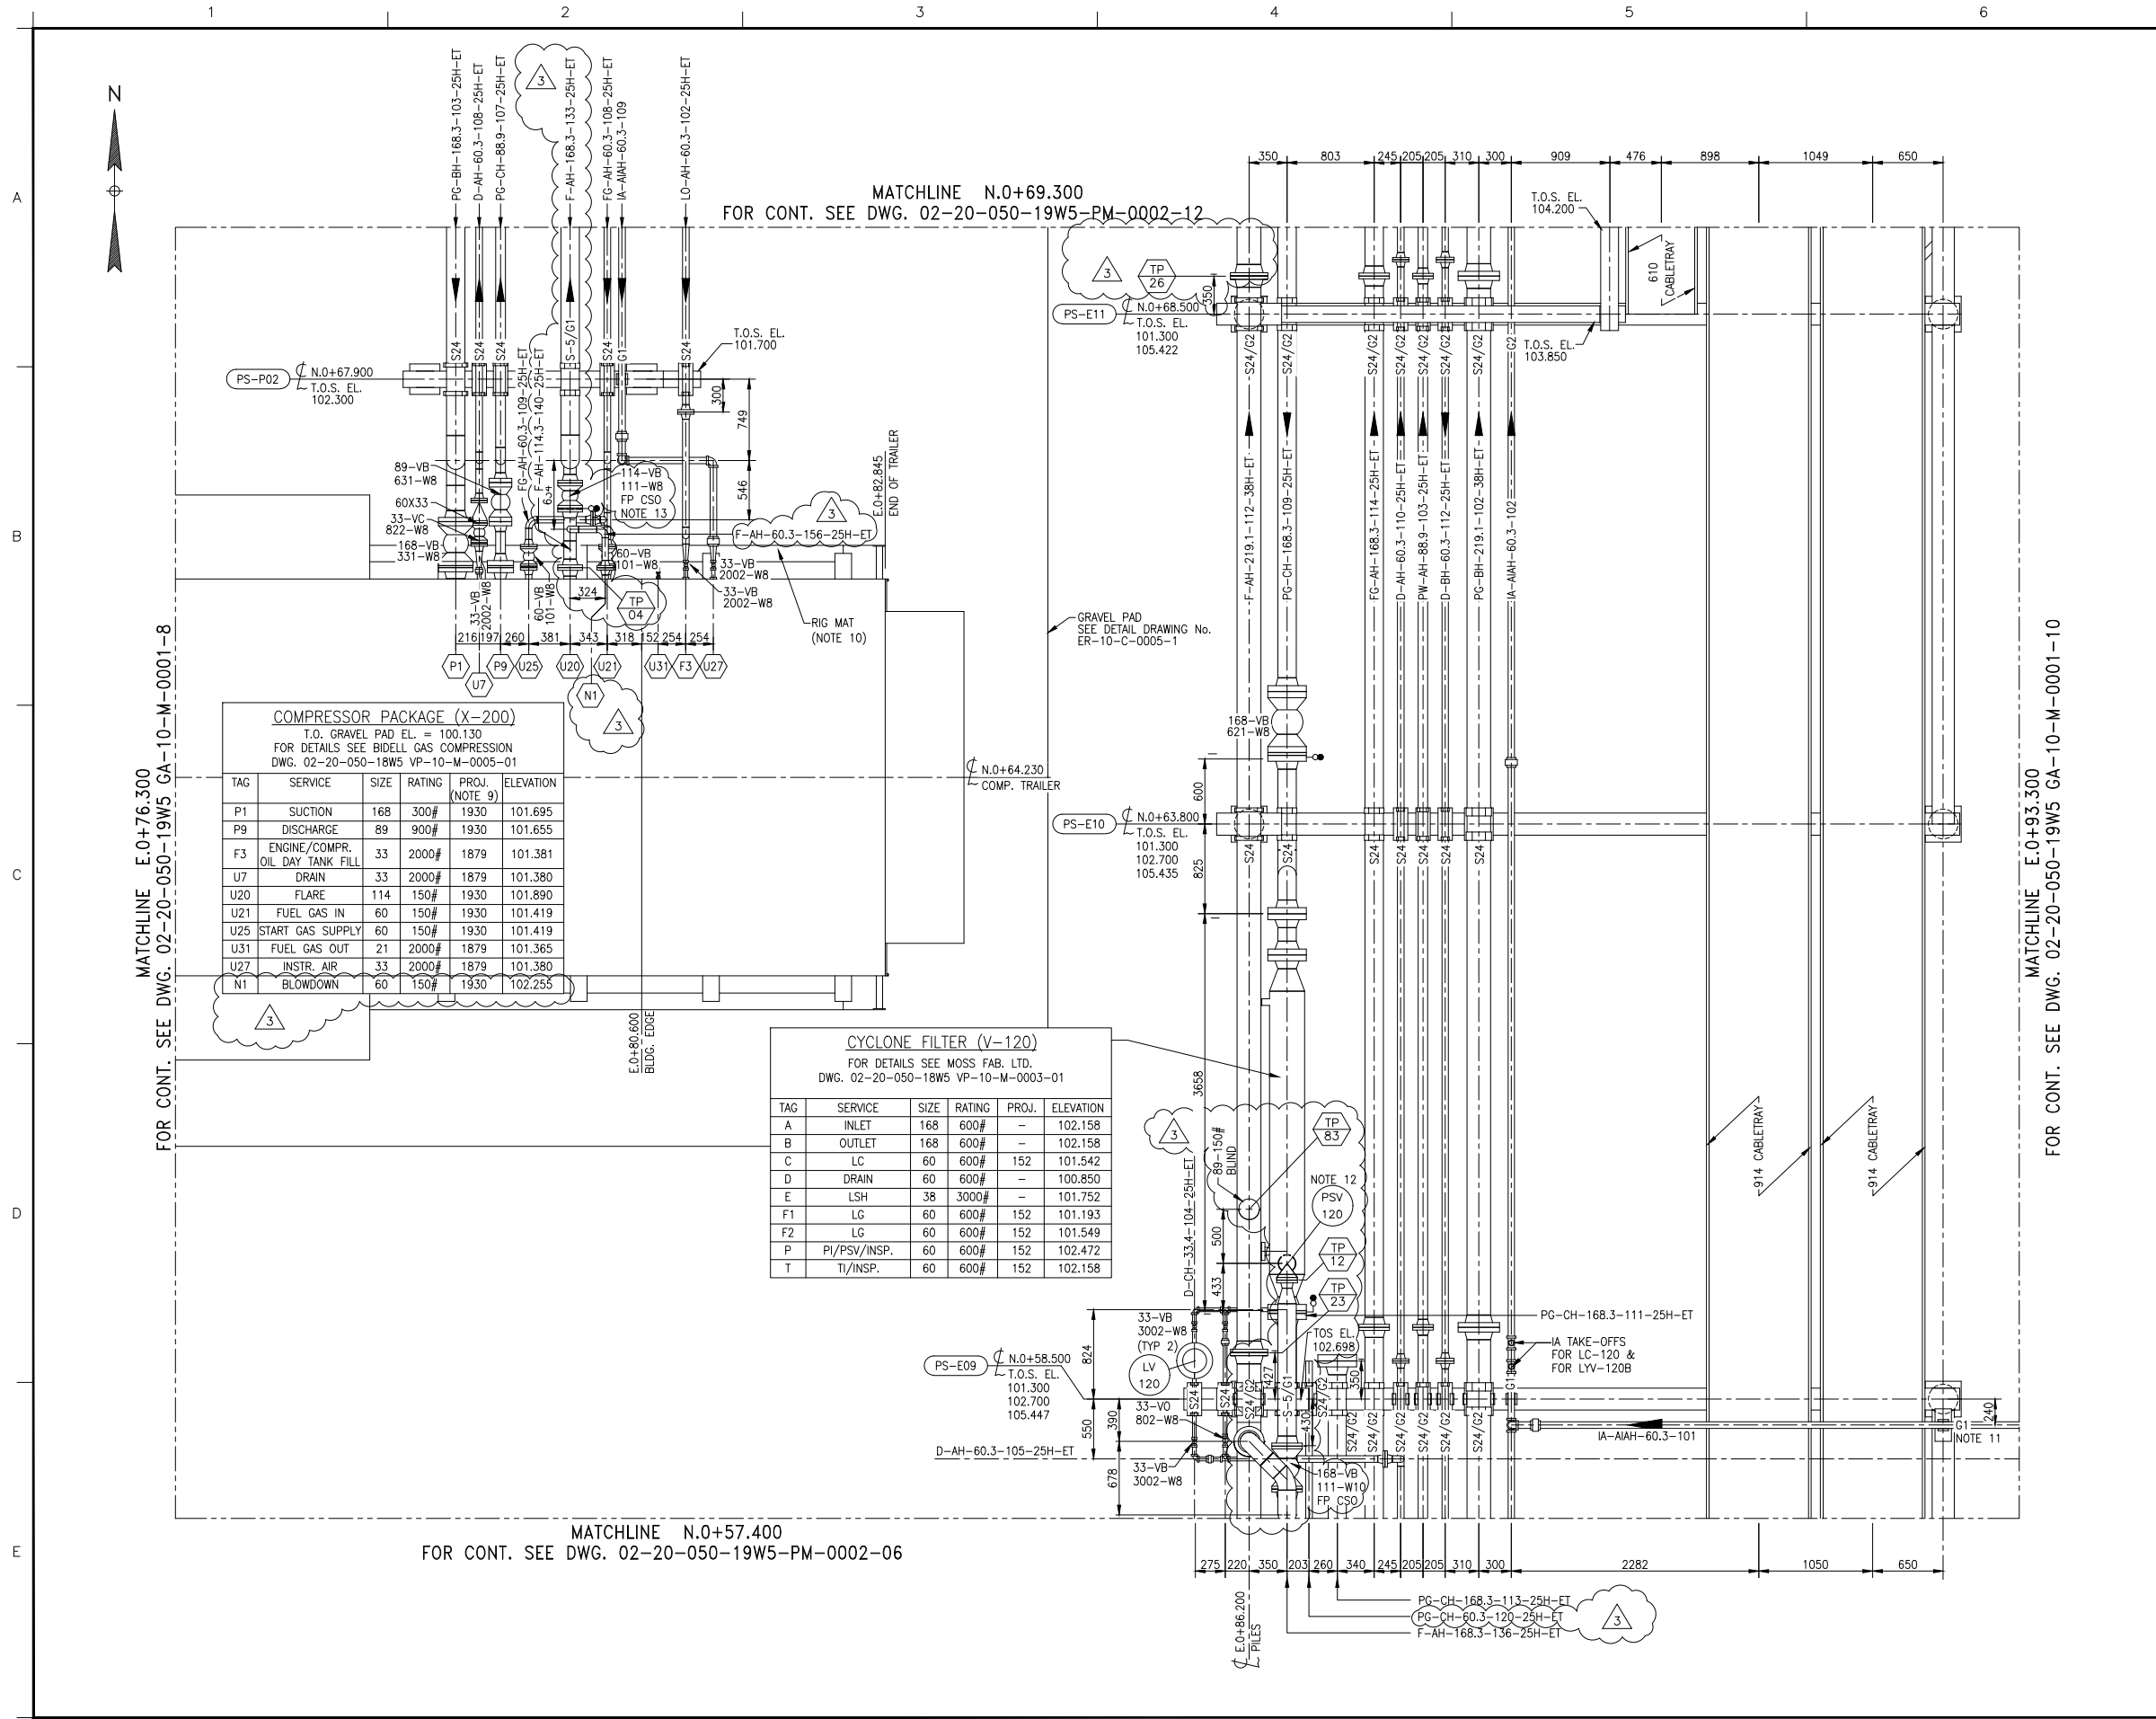

NOTES

- TRACE & OR INSULATE BURIED LINES TO BOTTOM OF TRENCH.
- ALL PROCESS & INSTRUMENT VENTS SHALL BE AT LEAST 500mm FROM ANY ELECTRICAL CONNECTION OR OUTLET.
- ▲ DENOTES VENDOR SUPPLIED ITEMS.
- FOR PIPE SHOES AND OTHER LINE SUPPORT DETAILS (eg. S24/G1) SEE STANDARD DRAWINGS 0100-000-STD-01.00.
- FOR PIPE SUPPORT DETAILS (eg. PS-AA01) SEE STRUCTURAL PIPE SUPPORT DRAWING 02-20-050-18W5 PS-10-S-0003-01 TO 12.
- CONTRACTOR TO PROVIDE & LOCATE 27mm VENTS & DRAINS AS REQUIRED FOR HYDROTESTING.
- WHERE SPECIFIED INSULATE ALL PIPING, VALVES & FLANGES WITH SPECIFIED THICKNESS FIBERGLASS W/ALUMINIUM CLADDING A/G & POLYURETHANE WITH TAPE U/G.
- GRADE ELEVATION VARIES, REFER TO GRADING PLAN FOR SITE ELEVATIONS DWG. 02-20-050-18W5 ER-10-C-0001-1.
- ALL NOZZLE PROJECTIONS FROM TRAILER CENTER LINE.
- SEE DRAWING 02-20-050-18W5 ER-10-C-0005-1 FOR PLACEMENT OF COMPRESSOR RIG MAT.
- REUSE EXISTING PIPE GUIDE.
- REUSE EXISTING PSV-120
- REUSE EXISTING 114-VB-111-WB AND 114-150# SPEC BLIND
- FOR S-5/G1 PIPE SUPPORT SEE SHOES, ANCHORS & GUIDES TYPICAL DETAILS DRAWING STD-001

ENGINEERING COMPANY PERMIT STAMP		REGISTERED PROFESSIONAL ENGINEER STAMP	

6				
5				
4				
3				
2				
1				
REF	DRAWING NUMBER	DRAWING TITLE		
REFERENCE DRAWINGS				
3	2017/03/10	IFC FOR EWR 22510 STANTEC 110902423	CML	
2	2014/12/12	IFC FOR EWR 19227 EXCELSIOR 4178HUS	TMD	KAB AM SA
1	2014/02/12	IFC FOR EWR 18319 EXCELSIOR 3829HUS	RP	KAB AM SA
REV	DATE	DESCRIPTION	BY	CHK ENG APR

REVISION HISTORY				
Husky Oil Operations Limited				
RAVEN CREEK 02-20-050-18W5 COMP STN				
TITLE COMPRESSOR PACKAGE (X-200), CYCLONE FILTER (V-120) GLYCOL STORAGE TANK (T-704) AREA GENERAL ARRANGEMENT				
SURFACE LOCATION		02-20-050-18W5		
ALTERNATE DWG NUMBER		GA-10-M-0001-9		REV NO
HUSKY DWG NUMBER		02-20-050-18W5-PM-0002-09		3
VENDOR DWG NUMBER				
AMU/FLOC NUMBER		W5-01-001-00007		
DCN NO		PROJECT NO EWR 22510		