


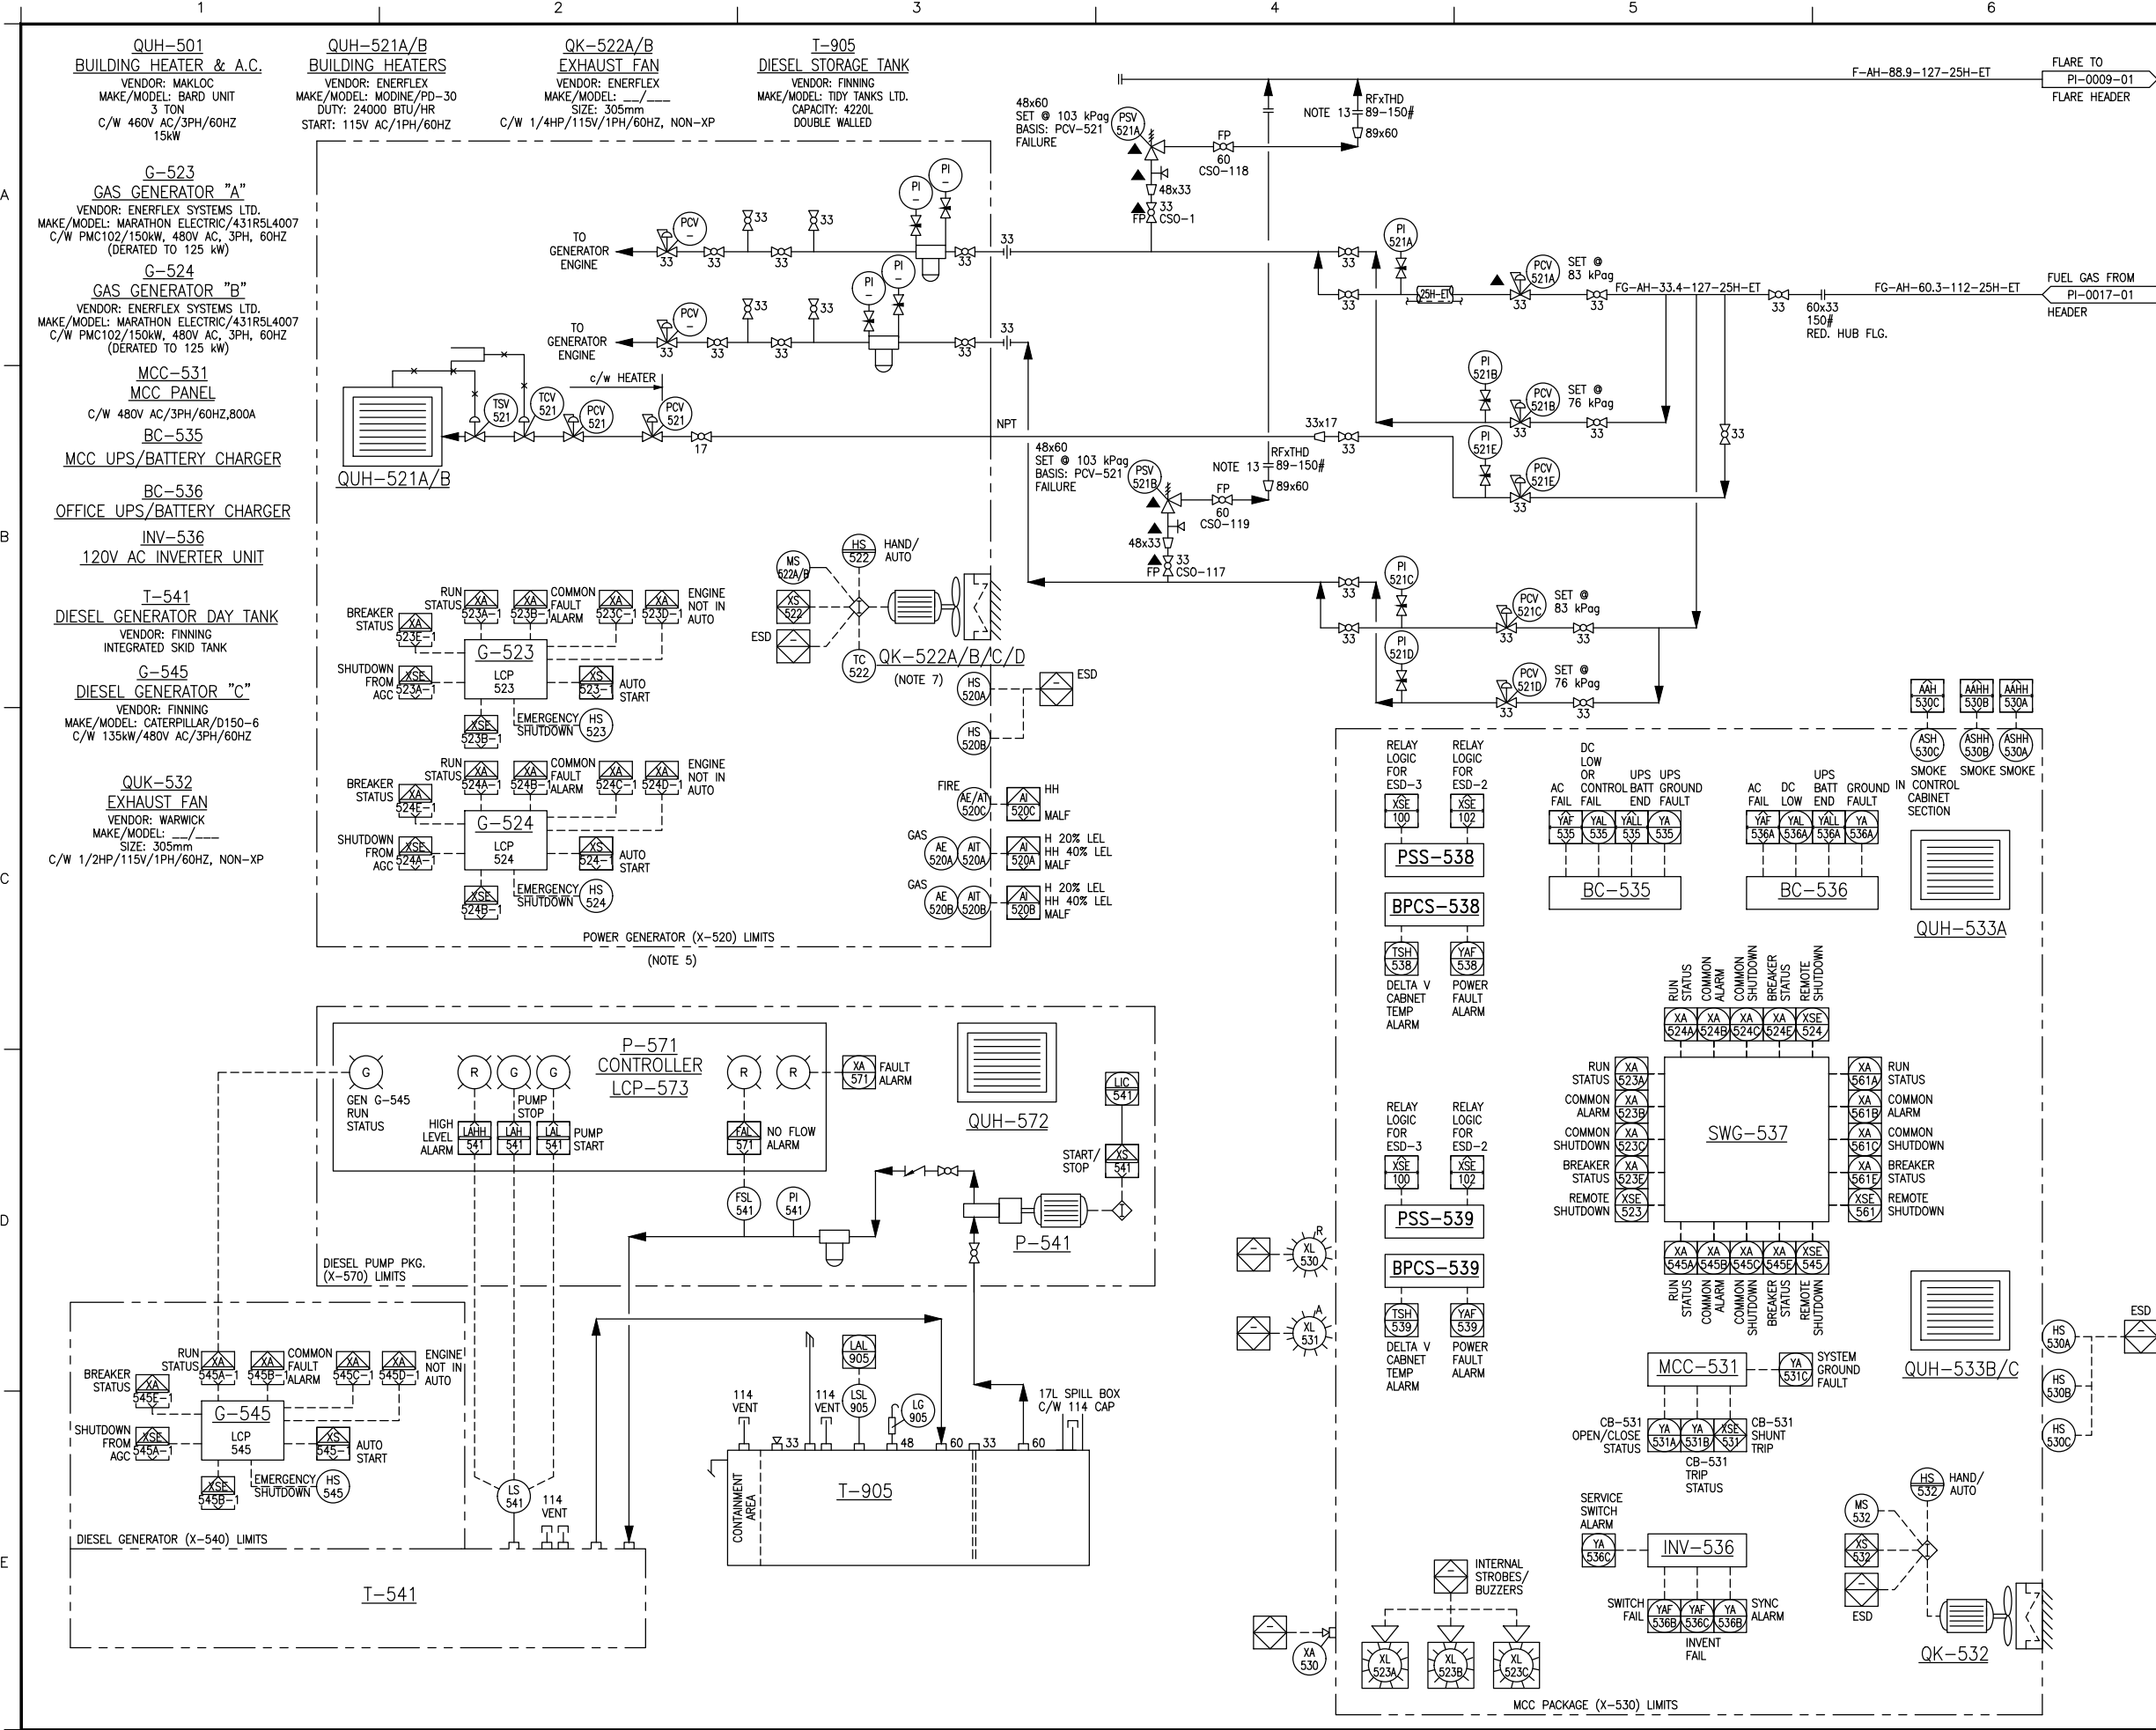

NOTES

- ALL PROCESS & INSTRUMENT VENTS SHALL BE AT LEAST 500mm FROM ANY ELECTRICAL CONNECTION OR OUTLET.
- INSULATE ALL A/G PIPE AND FLANGES WHERE SPECIFIED WITH FIBERGLASS INSULATION AND ALUMINIUM CLADDING.
- DELETED.
- FIELD TO SUPPLY VENTS AND DRAINS AS REQUIRED.
- FOR DETAILS, REFER TO THOMSON TECHNOLOGY DWG# W-03.
- TC-710 NOT IN USE, SUPPLIED WITH QK-710.
- FAN START AT 10% LEL AND BUILDING TEMPERATURE OF 15°C RISING.
- VENDOR PACKAGE P&ID WILL BE STAMPED BY VENDOR. FOR PURPOSE OF THIS DRAWING, ENGINEERING STAMP VERIFIES THAT THE VENDOR PACKAGE DRAWING (AS SHOWN) IS IN COMPLIANCE WITH THE HUSKY ENERGY HAZOP MEETING REQUIREMENTS AND RECOMMENDATIONS.
- DELETED
- B-TEX TANK T-902 MOVED TO PI-10-A-0018-1.
- DELETED.
- DELETED.
- THREADED BY WELDED CONCENTRIC REDUCER.

P-571
DIESEL TRANSFER PUMP
VENDOR: FINNING
MAKE/MODEL: ULTRALINE RS/RSC 177
RATING: 1800 RPM
C/W 0.5HP/115V/1PH/60HZ

QUH-572
ELECTRIC HEATER
VENDOR: FINNING
MAKE/MODEL: PENTAIR/DAH 1001A
C/W 100W/115V/1PH/60HZ

QUH-533A
BUILDING HEATER & A.C.
VENDOR: WARWICK
MAKE/MODEL: BARD UNIT
DUTY: 4 TON COOLING/15KW HEATING
C/W 460V/3PH/60HZ

QUH-533B/C
BUILDING HEATER
VENDOR: WARWICK
MAKE/MODEL: OUELLET/OAS
C/W: 460V AC/3PH/60HZ
10KW HEATING

ENGINEERING COMPANY PERMIT STAMP		REGISTERED PROFESSIONAL ENGINEER STAMP	
6			
5			
4			
3			
2			
1			
REF	DRAWING NUMBER	DRAWING TITLE	
REFERENCE DRAWINGS			
6	2018/01/18	AS BUILT FOR MOC EI 10875835 (CAR SEAL REVIEW)	KZ CM CM CM
5	2015/08/14	AS-BUILT FOR EWR 19227 EXCELSIOR 4411HUS	HH AM AM AM
4	2015/04/30	AS BUILT FOR EWR 19227 EXCELSIOR 4178HUS	KM TMD AM SA
3	2014/12/01	IFC FOR EWR 19227 EXCELSIOR 4178HUS	KM KAB AM SA
8	2019/04/10	AS BUILT FOR CC 80043755	PC BRM CM CM
7	2019/03/13	AS BUILT FOR EI 10904273	SK TW CM CG
REV	DATE	DESCRIPTION	BY CHK ENG APR
REVISION HISTORY			
Husky Oil Operations Limited			
RAVEN CREEK 02-20-050-18W5 COMP STN			
TITLE 02-20 OFFICE/MCC/GENERATOR/B-TEX CONDENSING TANK PIPING & INSTRUMENTATION DIAGRAM			
SURFACE LOCATION		02-20-050-18W5	
ALTERNATE DWG NUMBER	PI-10-A-0010-1	REV NO	8
HUSKY DWG NUMBER	02-20-050-18W5-PI-0010-01	VENDOR DWG NUMBER	SCALE
AMU/FLOC NUMBER	W5-01-001-00007		NTS
DCN NO	PROJECT NO	CC 80043755	