

TK-300/310  
METHANOL TANKS  
MAKE: NORTCO 500 GAL PLASTIC LOAF TANK  
c/w VENT CAP, FILL  
& GROUND TO SKID & VALVE, 500 IMP. GALLON  
MOUNTED ON EXTENDED SKID  
STACKED


P-300/310  
METHANOL PUMPS  
MAKE: TEXTTEAM MODEL MX-33-1  
c/w 3/8" PLUNGER,  
1/4" DISCHARGE & SUPPLY, 32.1 GAL/DAY MAX.  
6000 PSIG MAX DIS. PRESSURE  
c/w LG-300 (TKS RATE AND LEVEL GLASS)

BH-101A/B  
ELECTRIC BUILDING HEATERS  
MAKE: ELECTRIC RUFFNECK  
MODEL: FX412-480-360-10  
480 VOLT/ 3 PHASE/ 60 HZ  
XP, 10 KW OUTPUT ( 25,664 BTUH)  
c/w MOUNTING BRACKET  
ELECTRICAL BY OTHERS

V-100  
HORIZONTAL SEPARATOR  
REGISTERED IN AB & BC  
48" ID x 16'-0 S/S  
CA: 1/8"  
1440 psig @ 130°F  
RT-1, PWHT  
MANUFACTURED IN 2005  
MDMT-20°F @ 1440 PSIG  
SWEET SERVICE

V-110  
FUEL GAS SCRUBBER  
REGISTERED IN AB, SASK & BC  
6 5/8" OD x 36" S/S  
285 PSIG MAWP  
c/w HUSD-110A (INTEGRAL)  
GAS SUPPLIED FROM PROCESS  
MANUFACTURED IN 2006

EXF-140  
EXHAUST FAN  
120VAC, 12ACPH

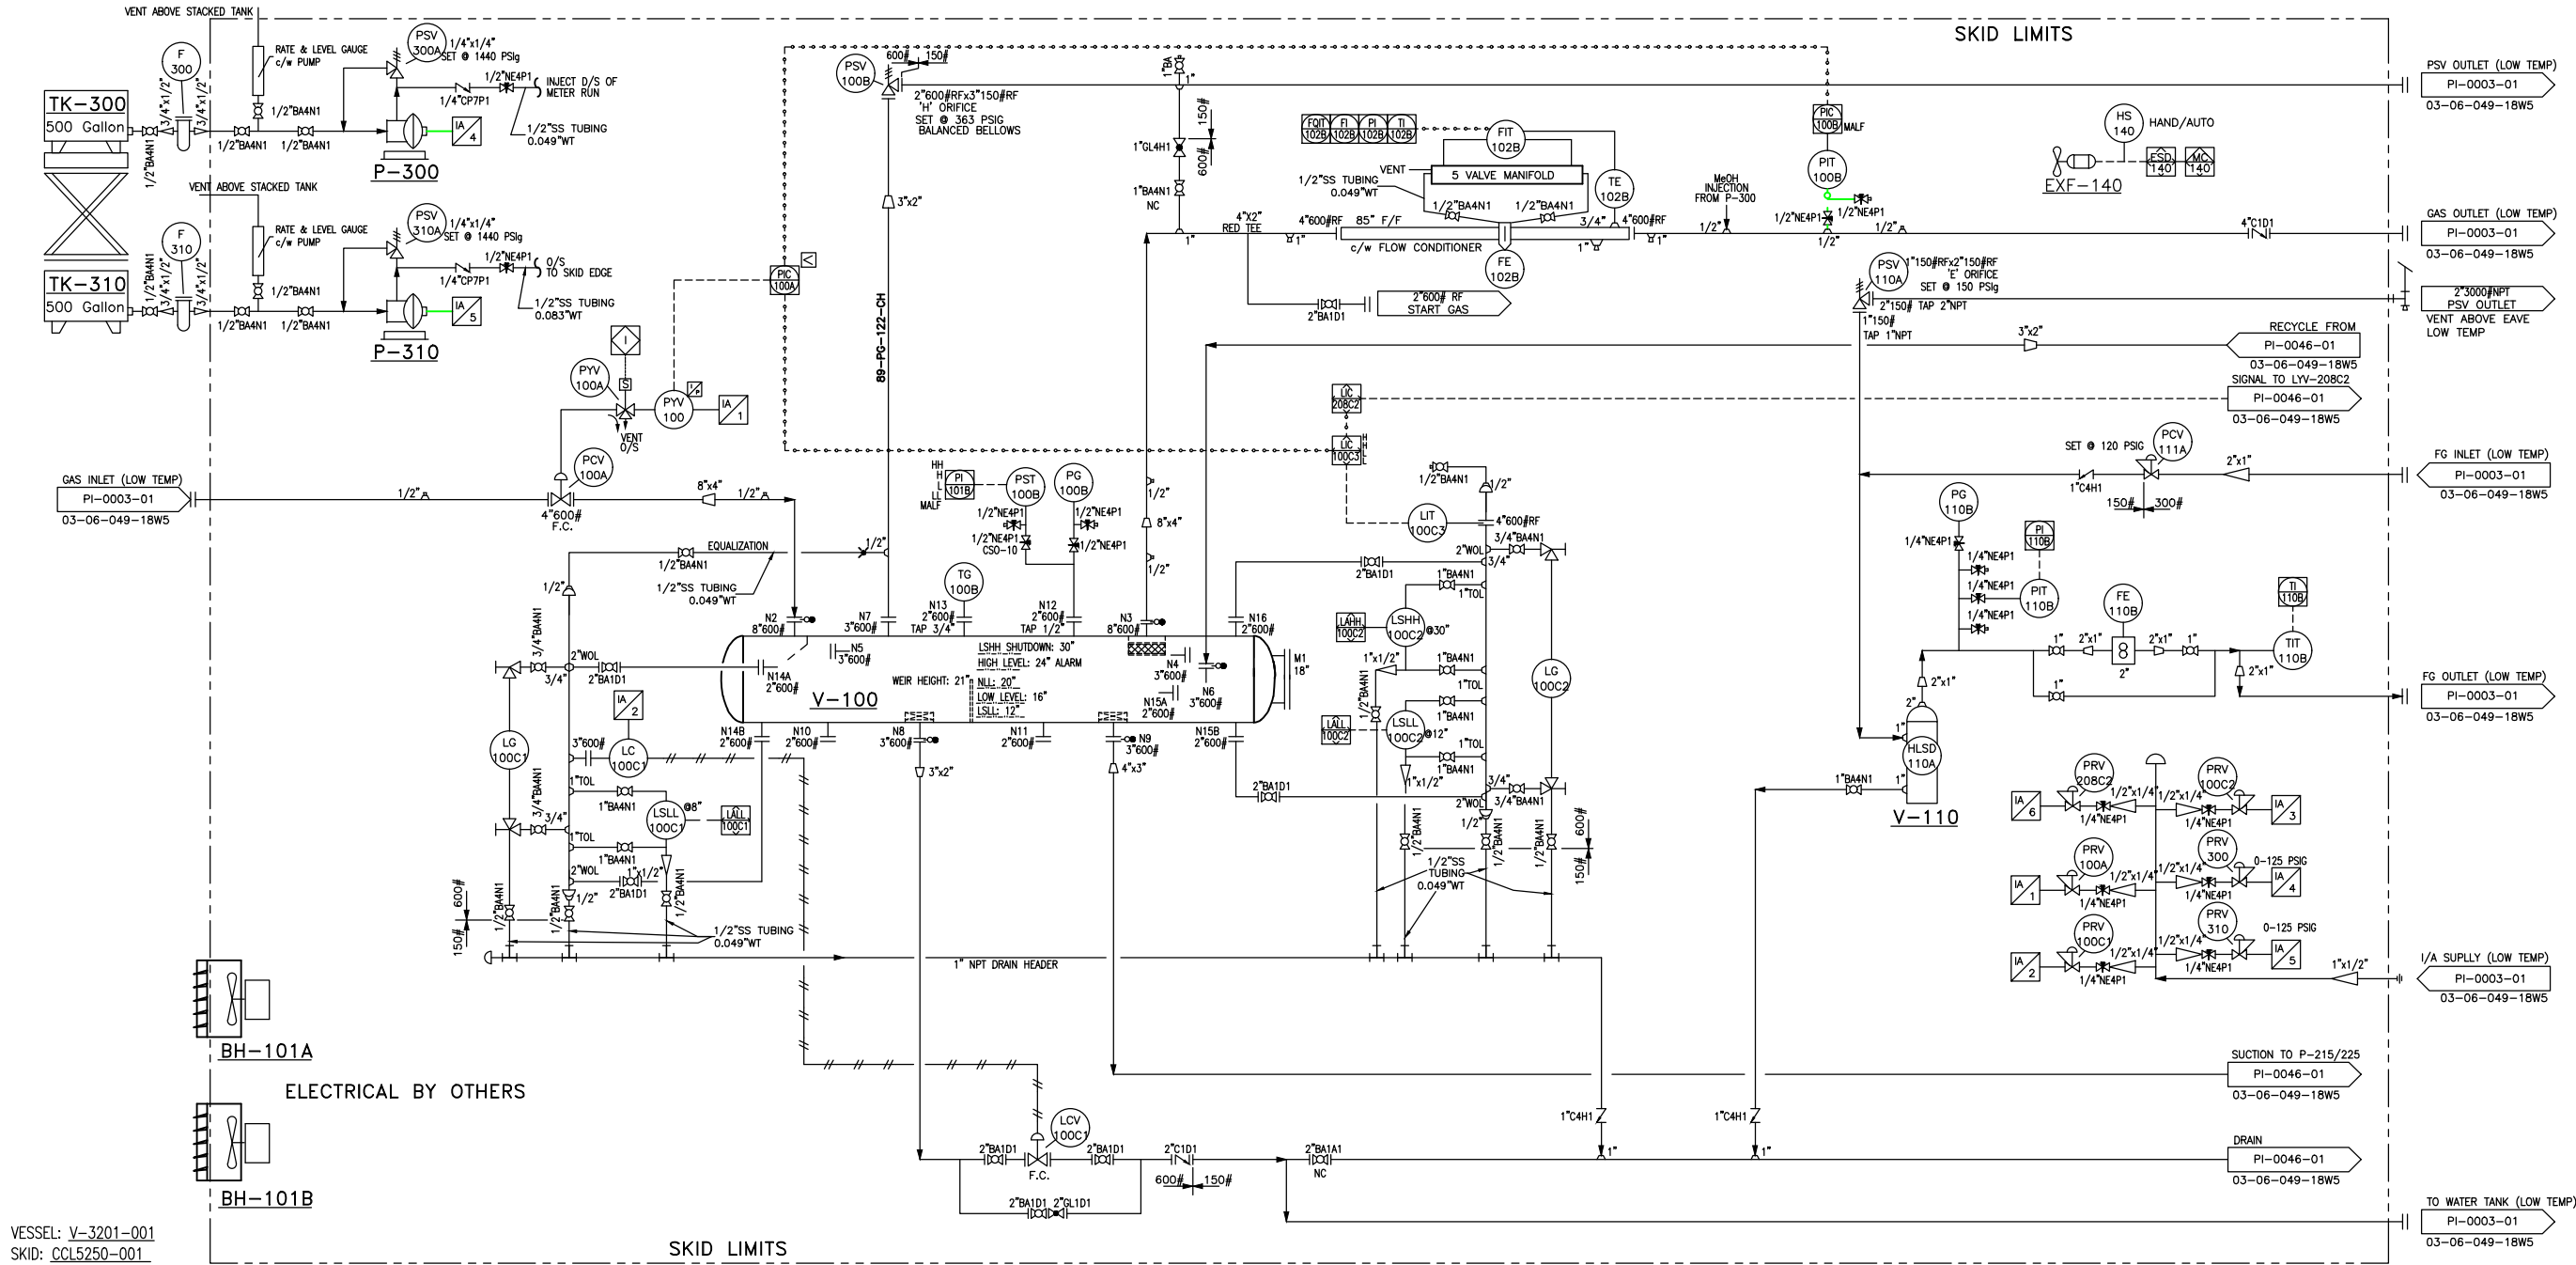

NOTES:  
1. ALL O/S FLANGES & PIPING TO BE LOW TEMP MATERIAL

| REF DWG NO | REFERENCE DRAWING DESCRIPTION | NO | REVISION HISTORY | REV AUTHOR | REV DATE | ISSUED FOR | NO | CURRENT REVISION                        | ISSUED FOR AS BUILT                   |
|------------|-------------------------------|----|------------------|------------|----------|------------|----|-----------------------------------------|---------------------------------------|
|            |                               | 1  |                  |            |          |            | 1  | CREATED FROM VV-0023-01 (MOC E10894387) | DOC DATE 2018/03/15                   |
|            |                               | 2  |                  |            |          |            |    |                                         | DOC AUTHOR KZ                         |
|            |                               | 3  |                  |            |          |            |    |                                         | SCALE NTS                             |
|            |                               | 4  |                  |            |          |            |    |                                         | ALTERNATE IDENTIFIER CCL-5325-001PIDS |
|            |                               | 5  |                  |            |          |            |    |                                         | SURFACE LSO 03-06-049-18W5            |
|            |                               | 6  |                  |            |          |            |    |                                         | DOCUMENT IDENTIFIER PI-0047-01        |
|            |                               | 7  |                  |            |          |            |    |                                         |                                       |

Husky Oil Operations Limited

ANSCELL 03-06-049-18W5 BOOSTER STN -SOUTH

COMPRESSOR STATION  
PIPING & INSTRUMENTATION DIAGRAM

CAD DRAWING: DO NOT CHANGE MANUALLY