


T-220
ASPHALTENE TANK
MFR: WESTEEL

P-221/P-222
MAKE: CUS/BRUIN
MODEL: D251/51031ABW21
PLUNGER: 3/8"
HUSKY NUMBER: 282682/282681

V-200
INLET SEPARATOR/SLUG CATCHER
SIZE: 2438mm ID x 10668mm S/S
DP: 3448 kPa @ -45.6/38°C
HUSKY NUMBER: 052129
MFR: RING PRO-TECH
SERIAL #: 38047A
A# 469496
CRN #: P7239.2

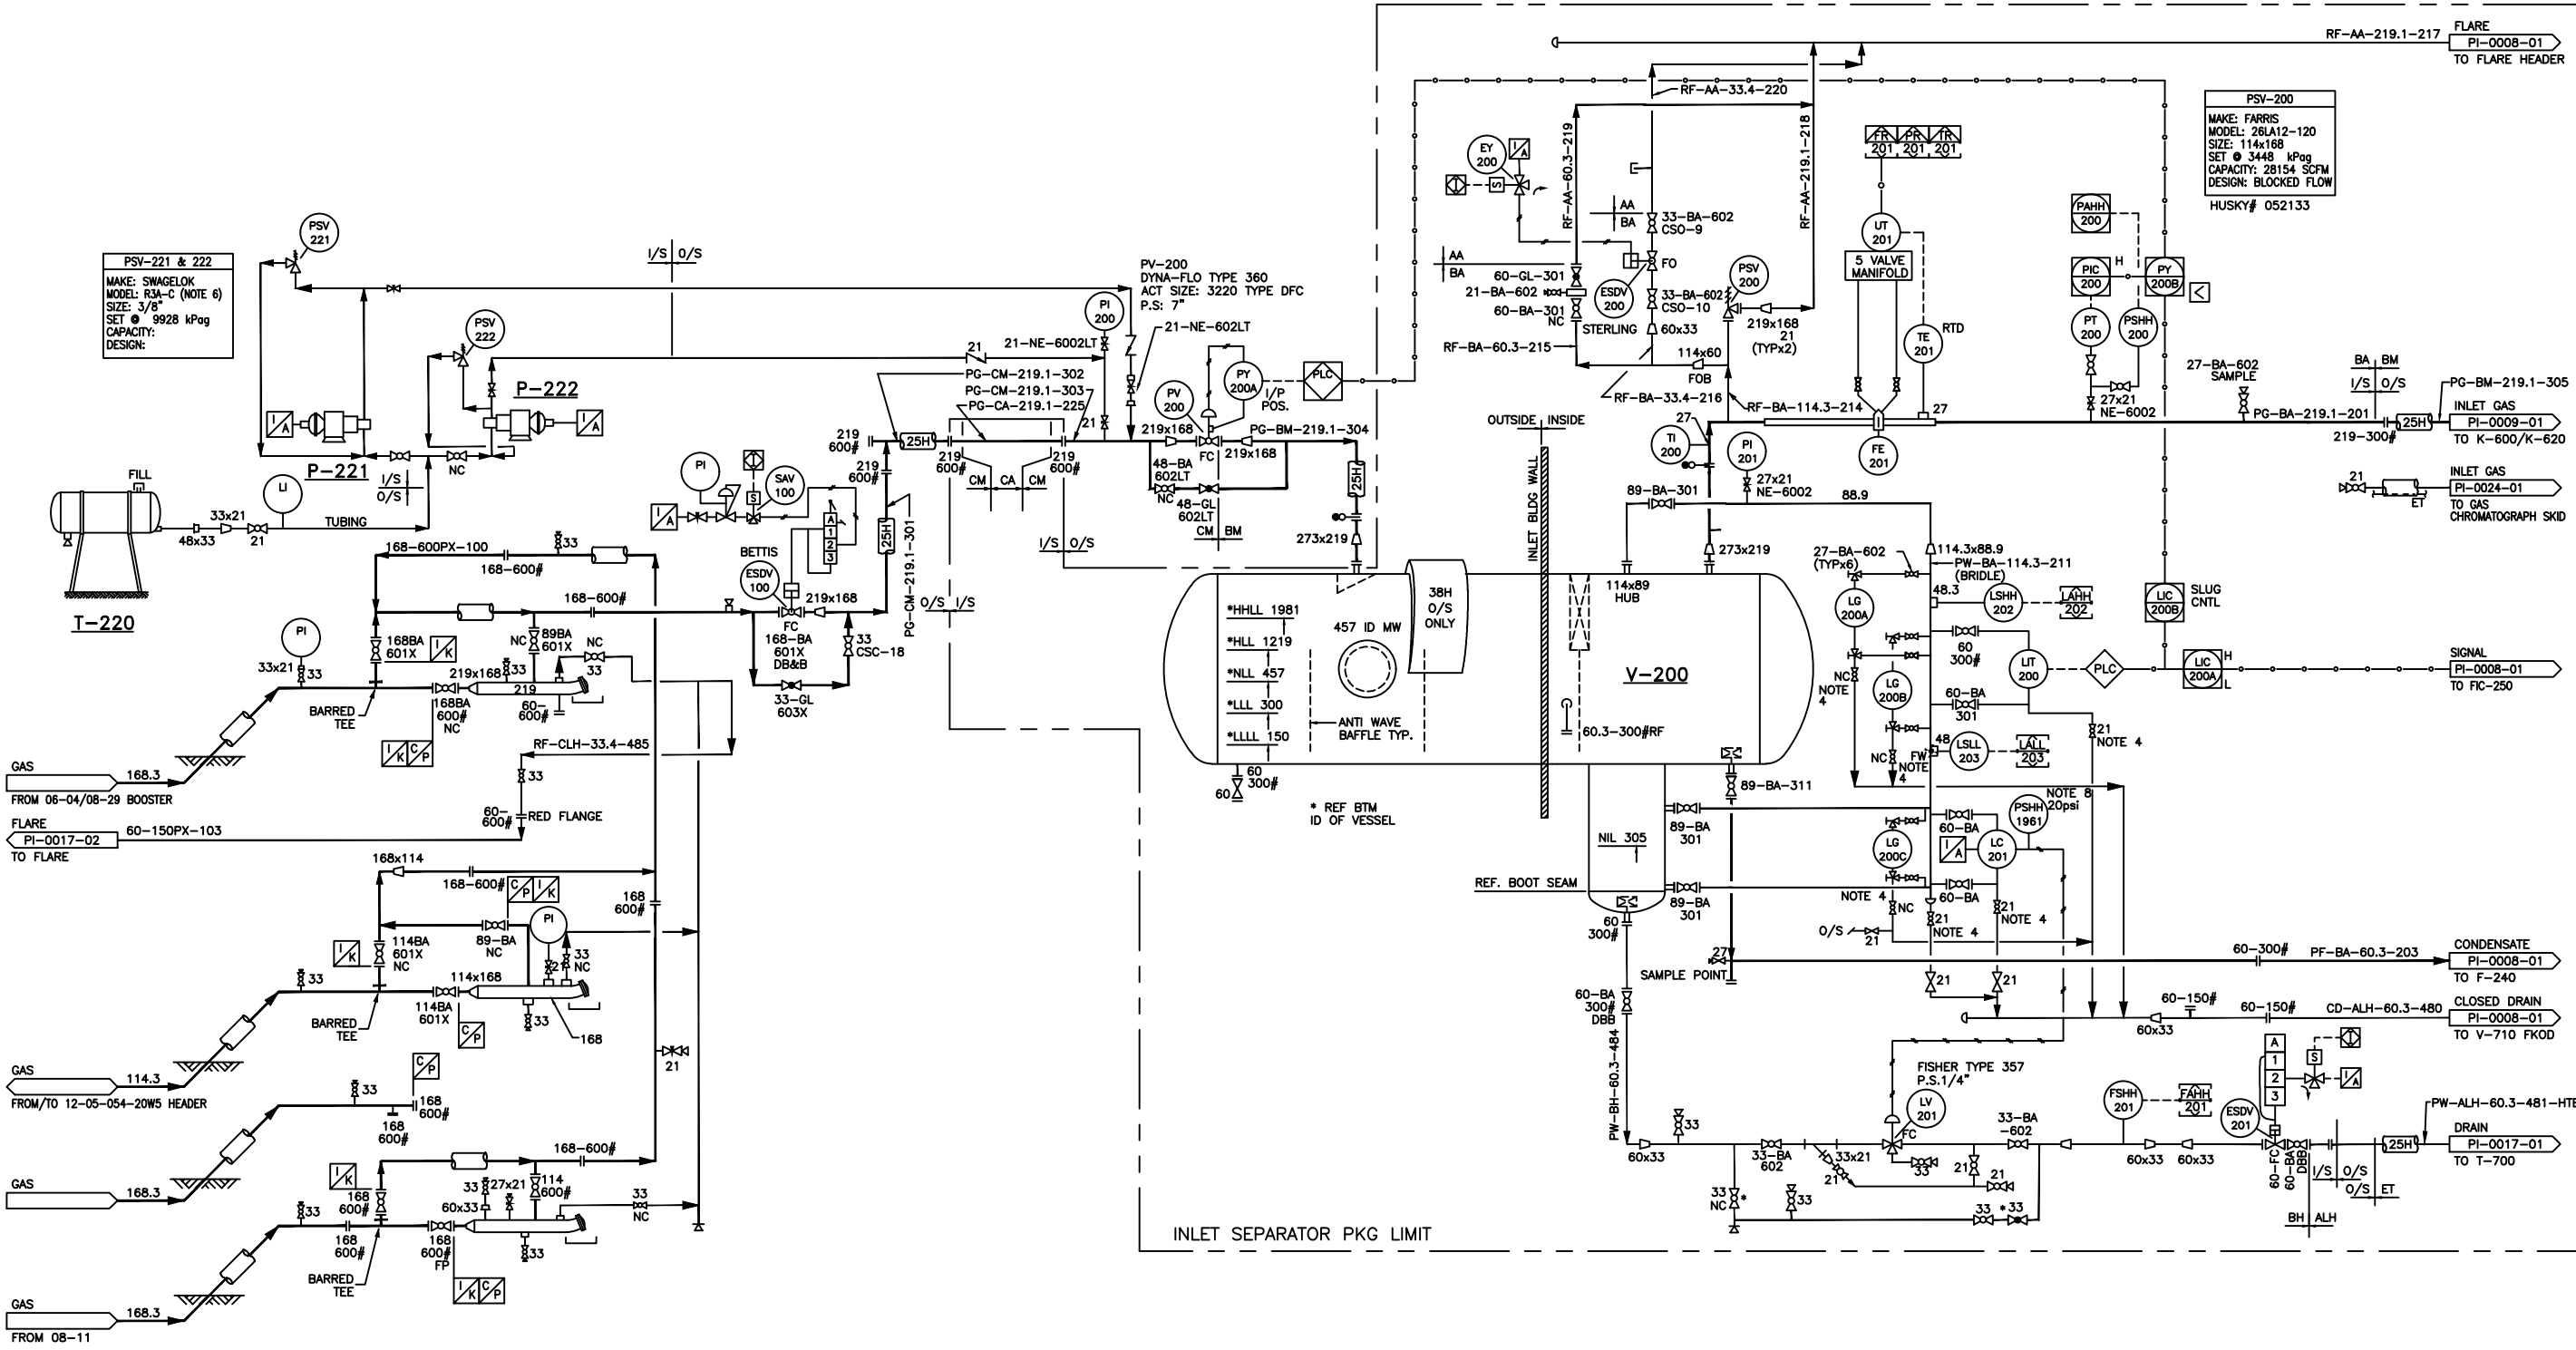

- NOTES:
1. DELETED.
2. DELETED.
3. DELETED.
4. SPRING LOADED VALVE. TO APPLY TO ALL INSTRUMENT DRAIN VALVES.
5. DELETED.
6. PURPLE SPRING.
7. DELETED.
8. PSHH-1961 FOR TRENDING OF WATER DUMP CYCLES. NO ACTION.

REF DWG NO	REFERENCE DRAWING DESCRIPTION	NO	REVISION HISTORY	REV	AUTHOR	REV DATE	ISSUED FOR	NO	CURRENT REVISION	ISSUED FOR	AS BUILT
		8	IFC FOR PO 8400944388 STANTEC 110901636-1930.6		STANTEC	2014/07/23	CONSTRUCTION	12	AS BUILT FOR CC 80071407		DOC DATE 2019/09/16
		9	IFC FOR PO 8400944388 STANTEC 110901636-1930.1		STANTEC	2015/08/07	CONSTRUCTION				DOC AUTHOR SK
		10	AS BUILT FOR MOC 16505775		BOB	2016/01/29	AS BUILT				SCALE NTS
		11	AS BUILT FOR MOC 10894388		LG	2018/03/23	AS BUILT				ALTERNATE IDENTIFIER 2076-11-PI-01
		5	FLARE MODIFICATIONS FOR EWR 11525-001		milled	2008/07/09	CONSTRUCTION				SURFACE LSP 12-05-054-20W5
		6	IFC FOR EWR 14817 STANTEC CS1544		STANTEC	2011/03/22	CONSTRUCTION				DOCUMENT IDENTIFIER PI-0007-01
		7	AS BUILT FOR EWR 19454 STANTEC 110618909		STANTEC	2014/07/23	AS BUILT				

Husky Oil Operations Limited
GALLOWAY 12-05-054-20W5 GAS PLANT
INLET SEPARATOR BUILDING
PIPING & INSTRUMENTATION DIAGRAM

CAD DRAWING: DO NOT CHANGE MANUALLY