



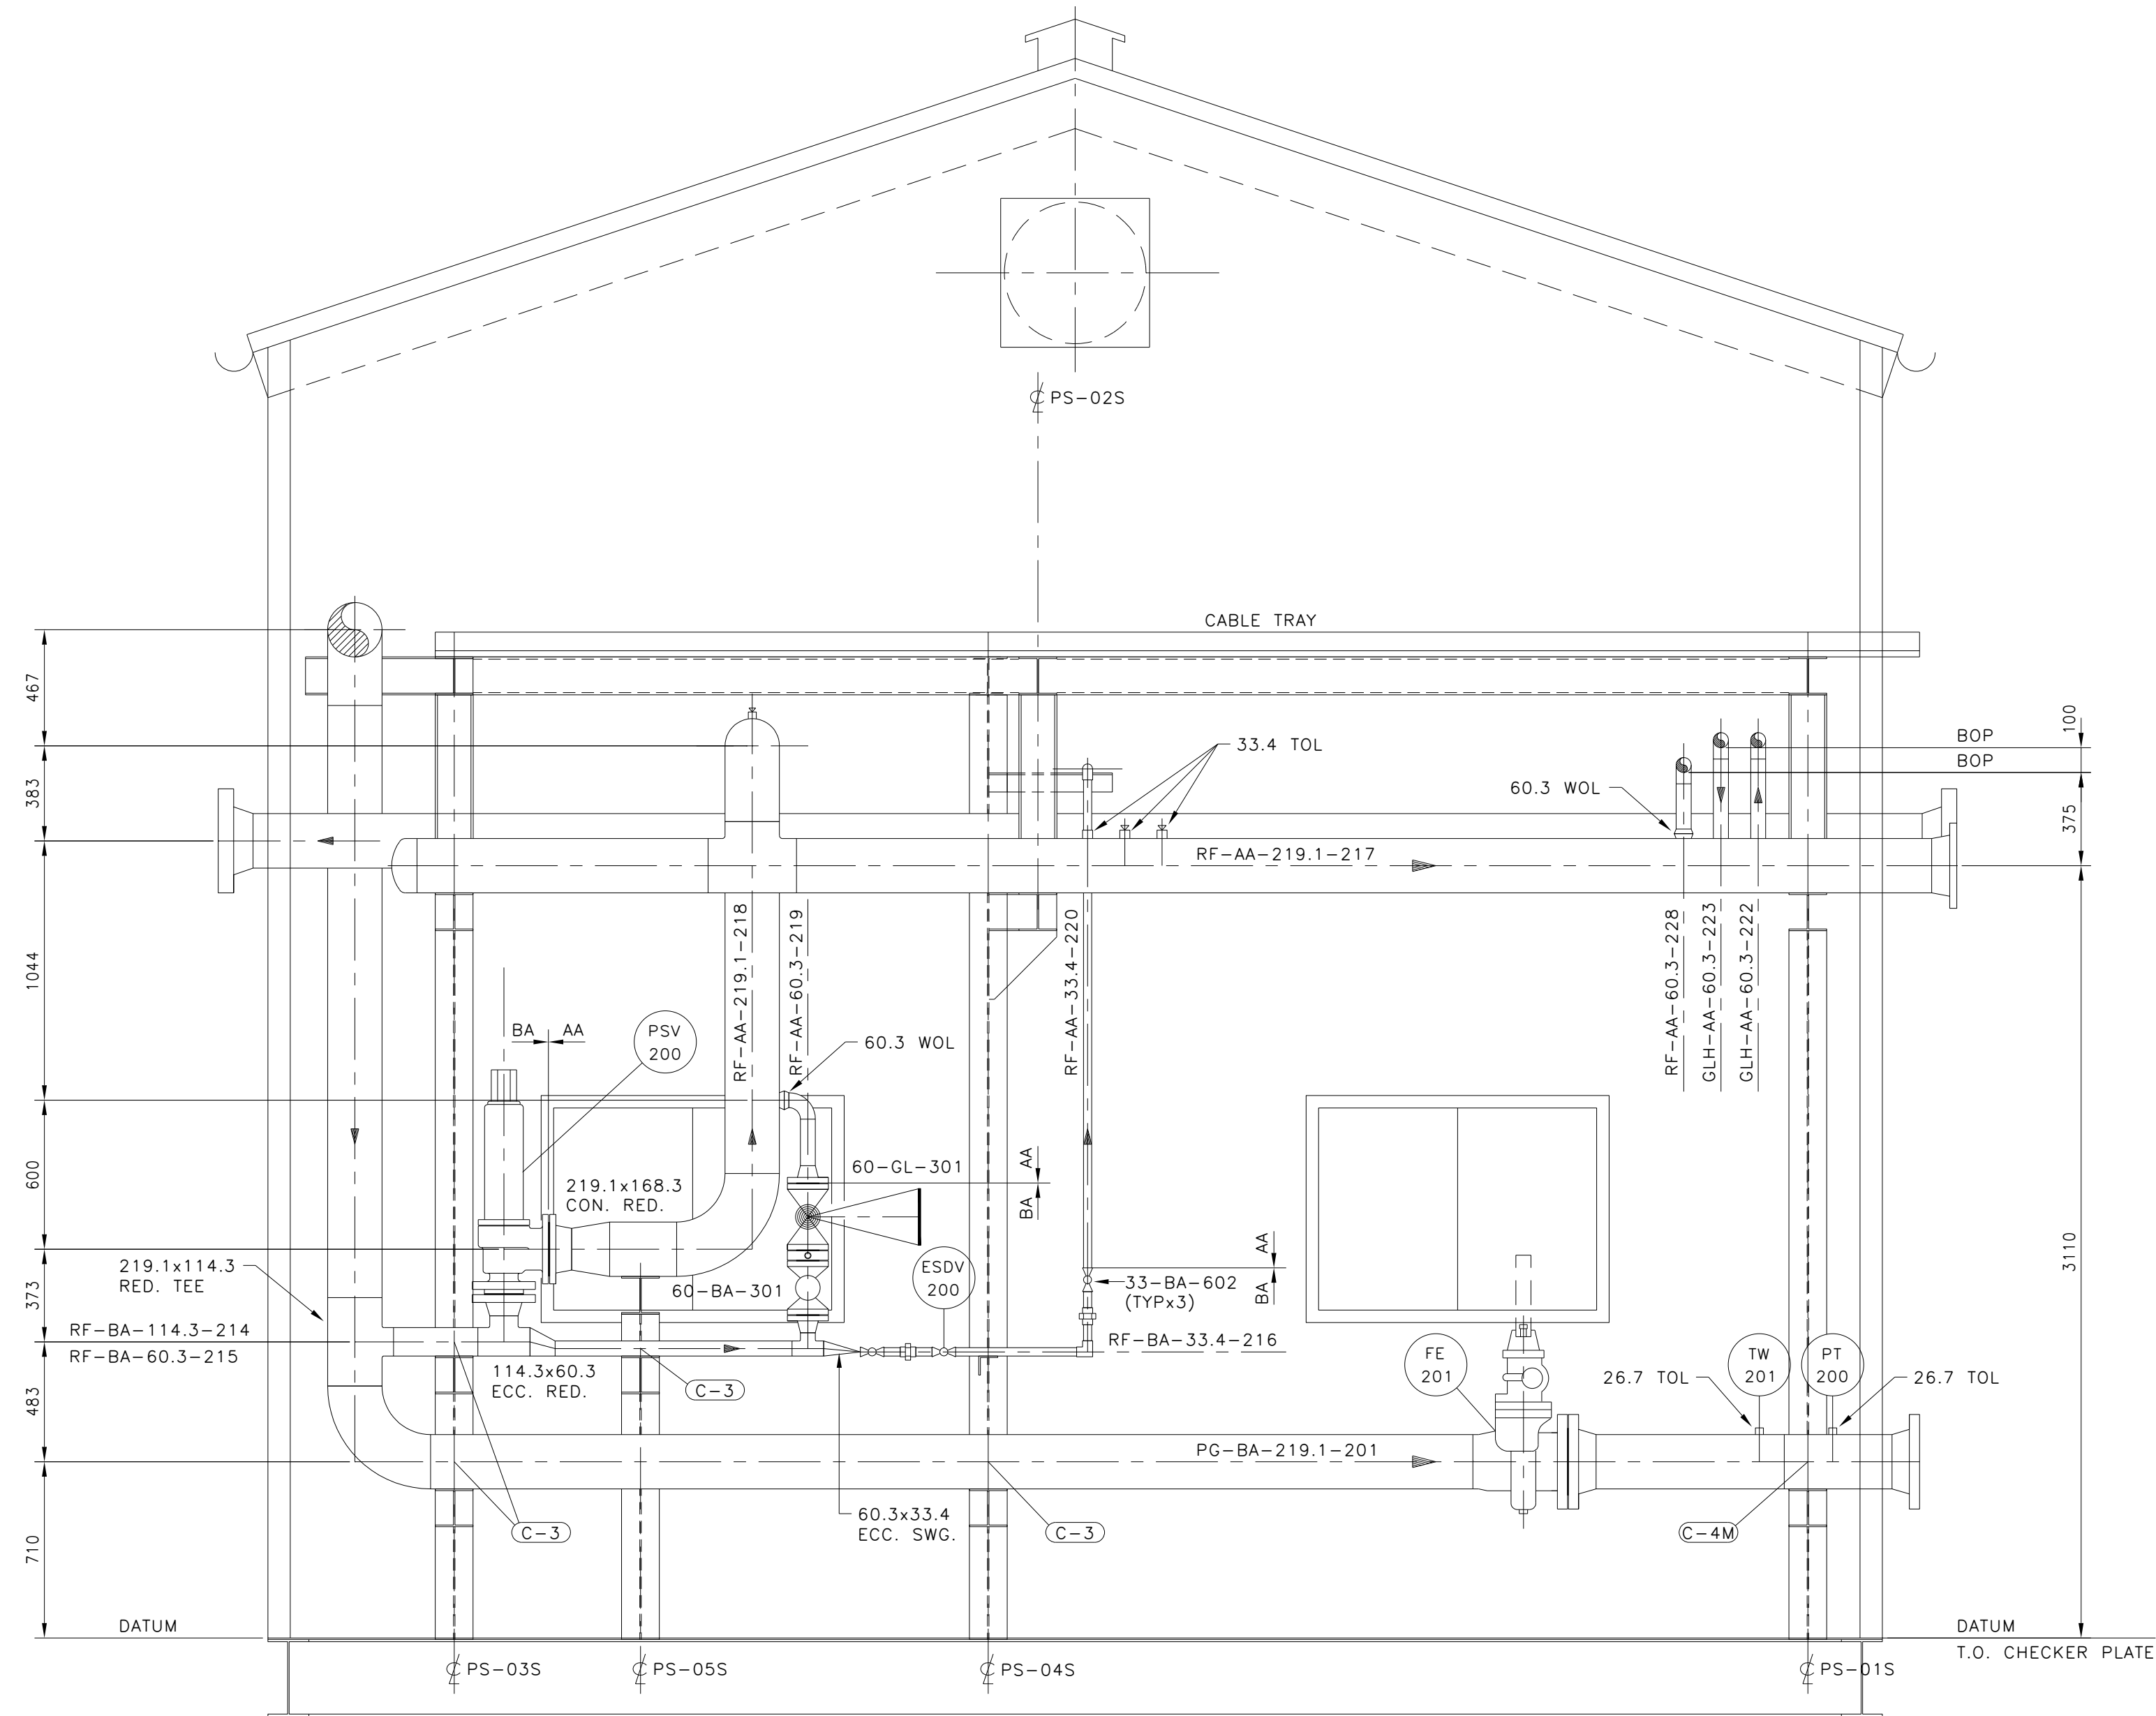

**B**  
**021** SECTION

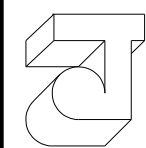

**TRIDYNE PROJECTS INC.**  
CALGARY ALBERTA

TRIDYNE DRAWING NO.:

TRIDYNE PROJECTS INC. JOB NO. 1009

| REFERENCE DRAWINGS |                                                      | REVISIONS |          |                                      |       |
|--------------------|------------------------------------------------------|-----------|----------|--------------------------------------|-------|
| PM-024             | STANDARD DRAWINGS - PIPE ANCHORS, GUIDES & SHOES     | 2         | 02-04-29 | AS-BUILT                             | VC    |
| PM-022             | INLET SEPARATOR/ SLUG CATCHER SKID - PIPING SECTIONS | 1         | 02-01-08 | ADDE C-4M PIPE CLAMP & RELOCATED C-3 | GL    |
| PM-021             | INLET SEPARATOR/ SLUG CATCHER SKID - PIPING PLAN     | C         | 01-12-12 | ELEVATED EAVE HEIGHT                 | DGH   |
| NUMBER             | TITLE                                                | NO.       | DATE     | DESCRIPTION                          | BY    |
|                    |                                                      |           |          |                                      | APP'D |

|                   |                |
|-------------------|----------------|
| JOB NO.           | TRIDYNE # 1009 |
| DRAWN BY          | GL             |
| CHECKED BY        | GL             |
| APPROVED BY       | GL             |
| ORIGINATING DEPT. |                |

HUSKY OIL OPERATIONS LTD.

ROSEVEAR-GALLOWAY COMPRESSOR STATION

INLET SEPARATOR/ SLUG CATCHER SKID

PIPING SECTION

**Husky Oil**

|                |      |
|----------------|------|
| SCALE          |      |
| 1:20           |      |
| DATE           | FILE |
| 01-09-20       |      |
| DRAWING NO.    | REV. |
| 2076-11-PM-023 | 2    |