


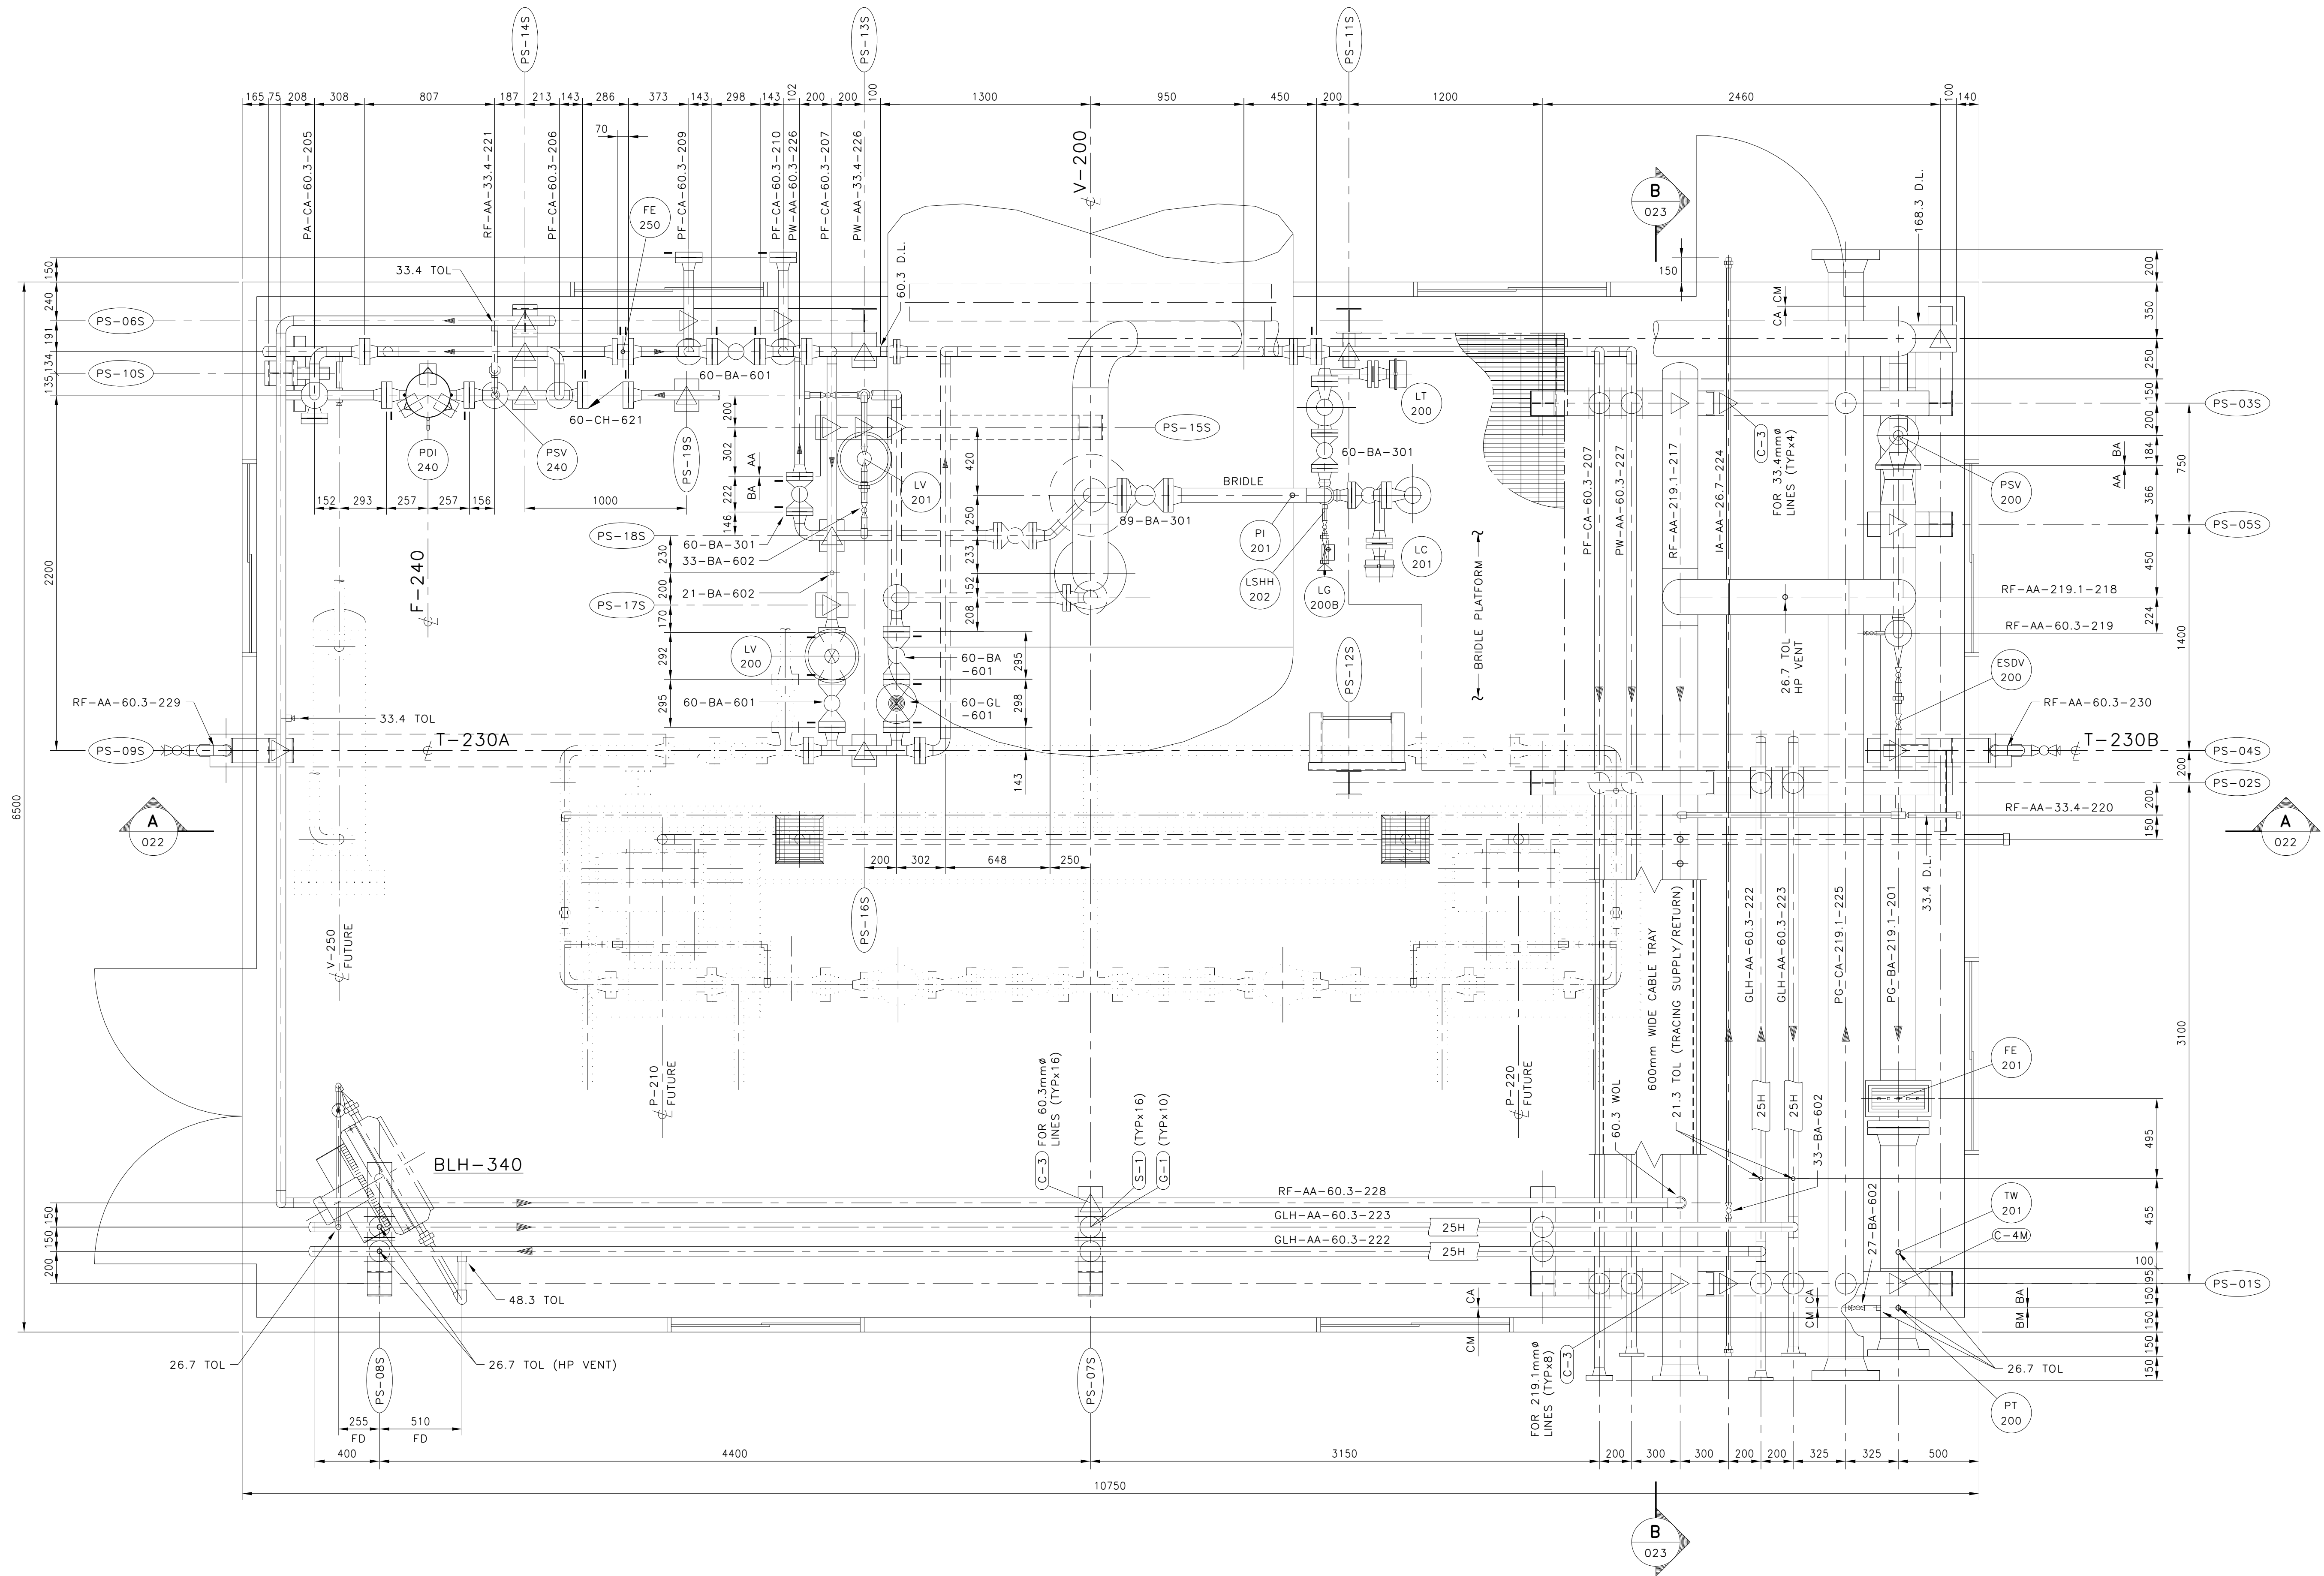

NUMBER	TITLE
PM-024	STANDARD DRAWINGS - PIPE ANCHORS, GUIDES & SHOES
PM-023	INLET SEPARATOR/ SLUG CATCHER SKID - PIPING SECTIONS
PM-022	INLET SEPARATOR/ SLUG CATCHER SKID - PIPING SECTIONS

NO.	DATE	DESCRIPTION	BY	APP'D
3	02-04-29	AS-BUILT	VC	
2	02-01-08	ADDED C-4M PIPE CLAMP	GL	
1	01-12-06	EXTENDED INSTR. AIR LINE OUTSIDE BLDG. WALL	DGH	
B	01-11-06	ISSUED FOR SHOP CONSTRUCTION	GL	
A	01-10-19	ISSUED FOR BID	GL	

JOB NO. TRIDYNE # 1009
DRAWN BY GL
CHECKED BY
APPROVED BY
ORIGINATING DEPT.

HUSKY OIL OPERATIONS LTD.
ROSEVEAR-GALLOWAY COMPRESSOR STATION
INLET SEPARATOR/ SLUG CATCHER SKID
PIPING PLAN

Husky Oil	
SCALE 1:20	DATE 01-09-20
DRAWING NO. 2076-11-PM-021	REV. 3

