
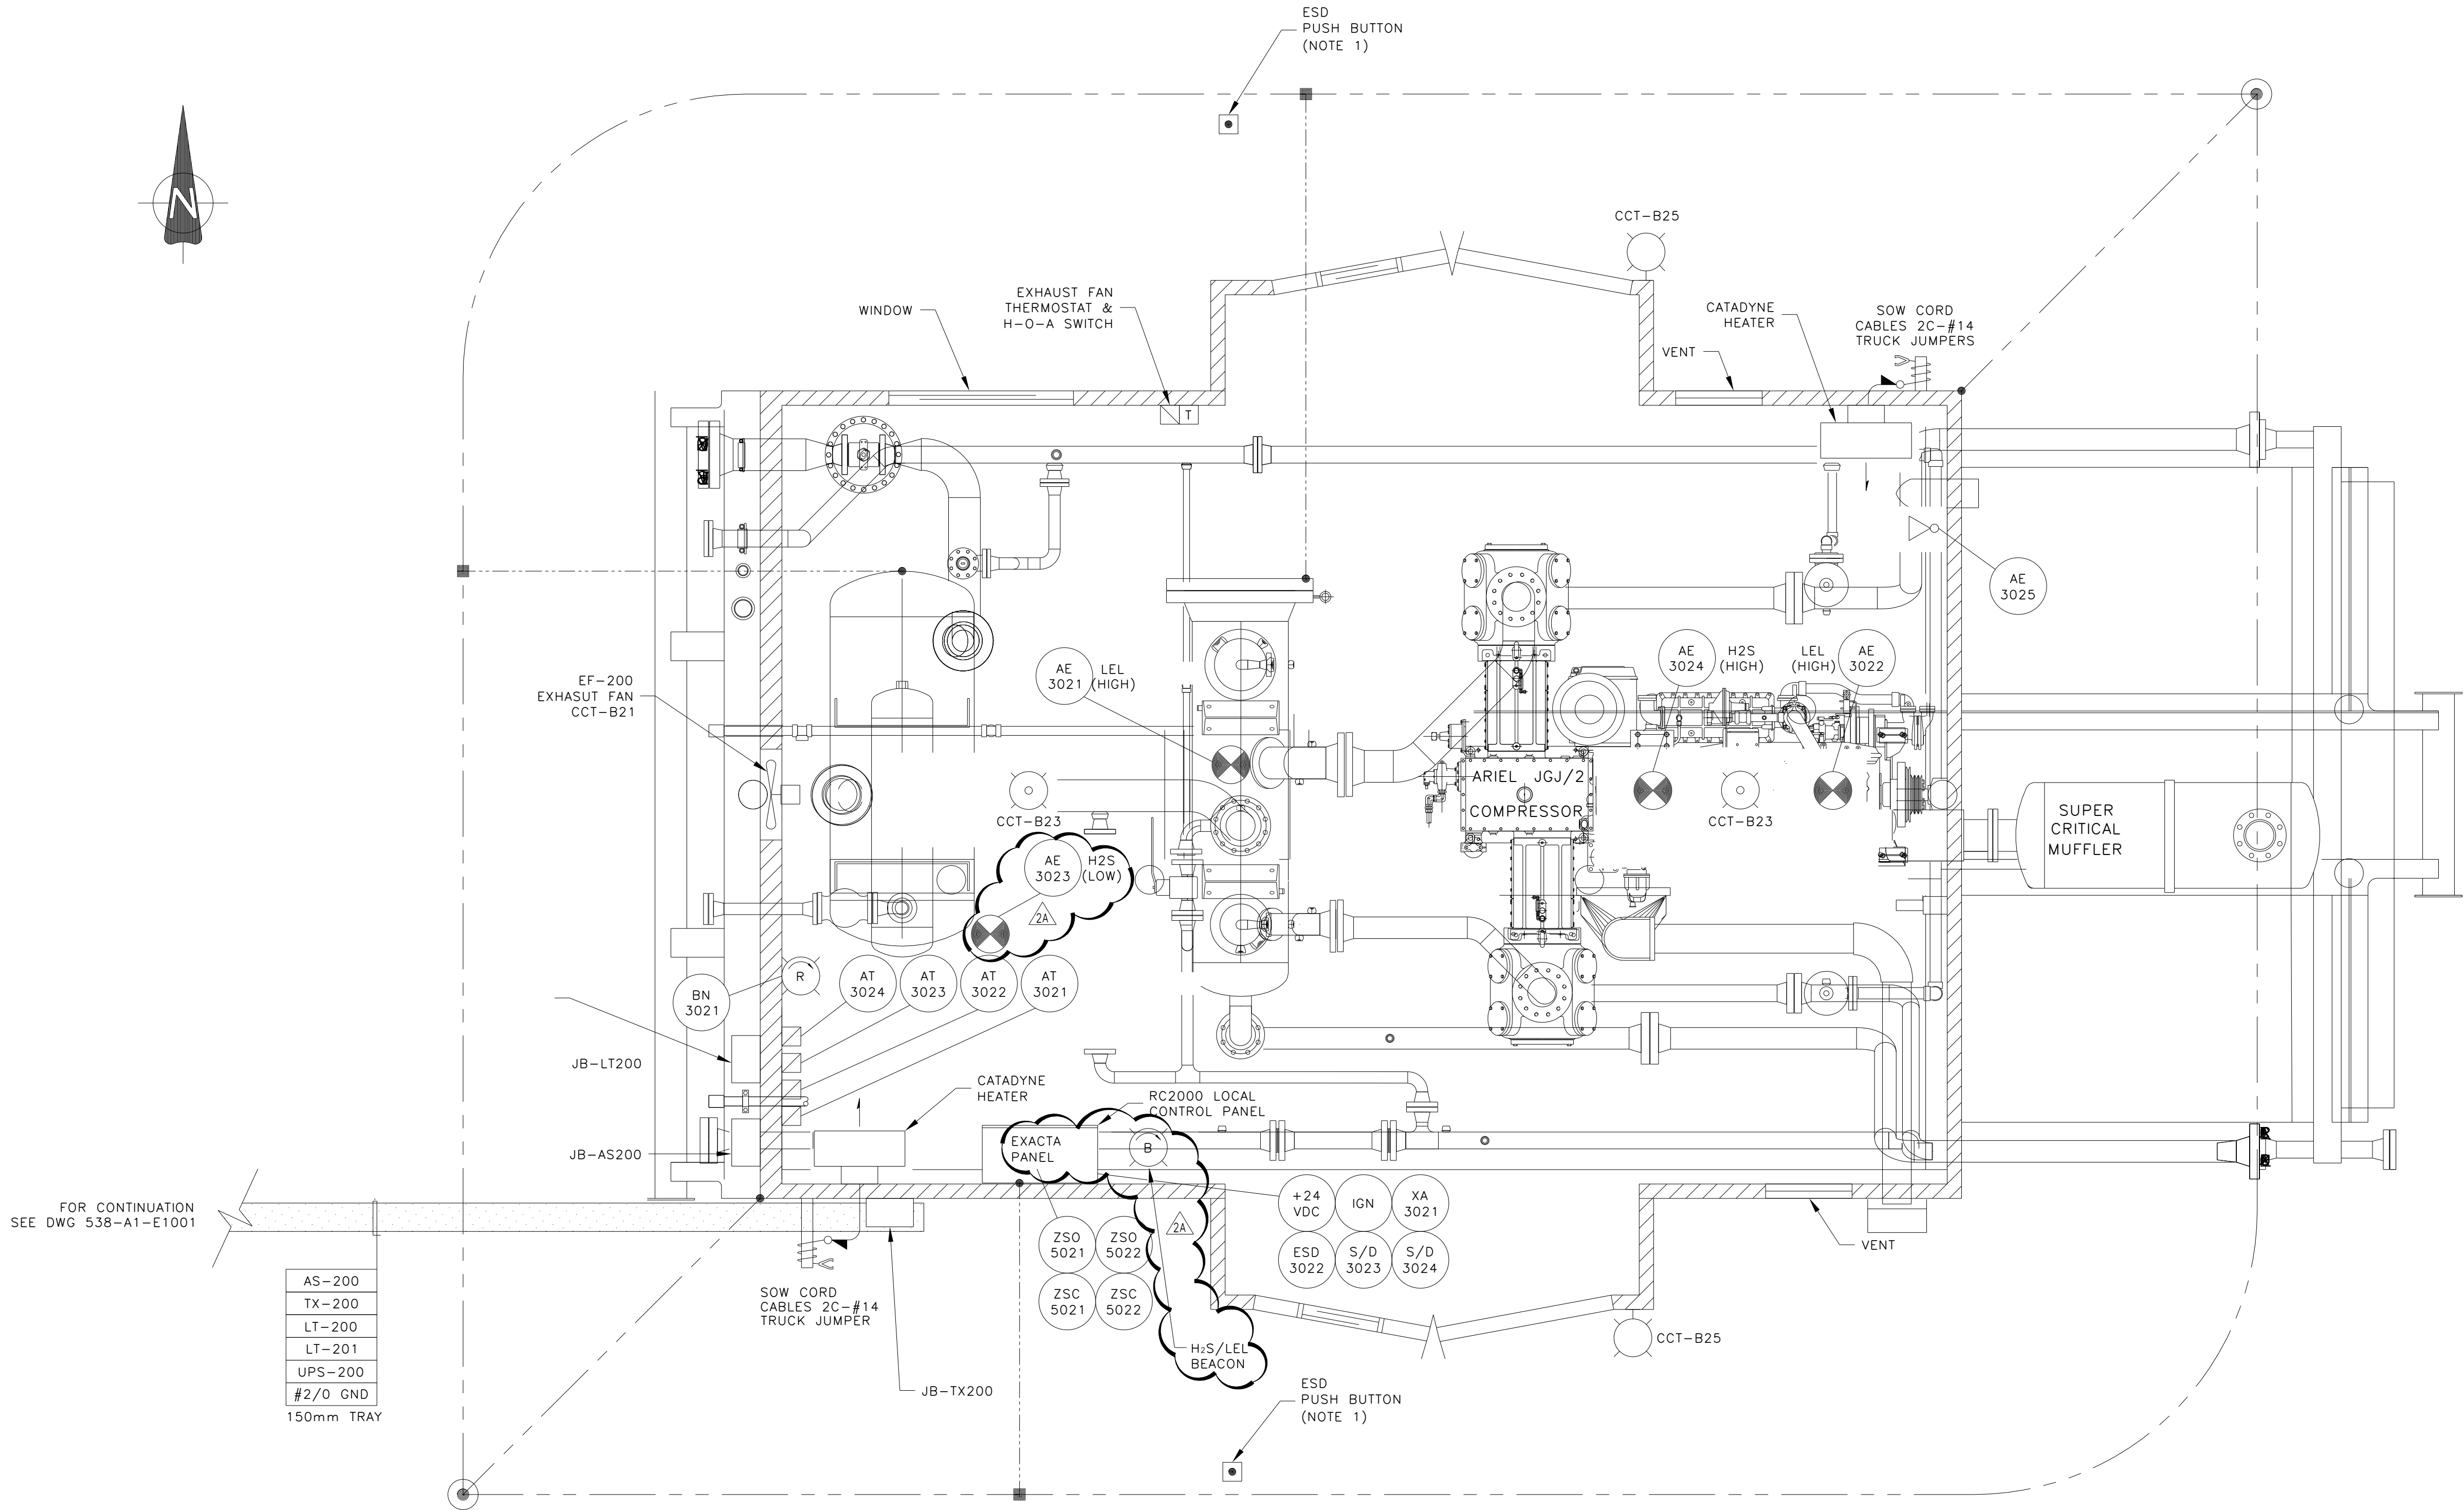


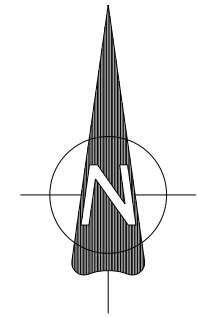

- NOTES
1. FIELD TO LOCATE ESD PUSH BUTTONS ON STAIRCASE RAILINGS.
  2. ALTERNATOR AND BATTERIES TO BE DECOMISSIONED. PANEL POWER TO BE TIED INTO 24VDC UPS.

|                                                                                                                                                                                                                         |  |                                                                        |                                                          |
|-------------------------------------------------------------------------------------------------------------------------------------------------------------------------------------------------------------------------|--|------------------------------------------------------------------------|----------------------------------------------------------|
| <div>ExxonMobil</div>                                                                                                                                                                                                   |  | <div>EXXONMOBIL CANADA LTD.</div> <div>06-22-057-20W5-EL-0018-01</div> |                                                          |
| <div>KAYBOB PINE CREEK</div> <div>06-22-057-20 W5M K-02 BOOSTER COMPRESSOR BUILDING</div> <div>ELECTRICAL LAYOUT</div> <div></div> |  |                                                                        |                                                          |
| <div>CONTRACTOR NAME</div> <div>BANYAN ENGINEERING LTD.</div>                                                                                                                                                           |  | <div>SCALE</div> <div>1:20</div>                                       | <div>EMCW DRAWING NUMBER</div> <div>538-D-E2205 01</div> |
| <div>CONTRACTOR DWG NUMBER</div> <div>B24500-10</div>                                                                                                                                                                   |  |                                                                        | <div>REV.</div> <div>2A</div>                            |

|     |  |          |                                                |       |       |        |       |              |       |                    |
|-----|--|----------|------------------------------------------------|-------|-------|--------|-------|--------------|-------|--------------------|
| NO. |  | DATE     | REVISIONS                                      | DRAWN | CHECK | DESIGN | APPR. | EMCW DWG NO. | TITLE | REFERENCE DRAWINGS |
| 2A  |  | 04 06 15 | UPDATED AS PER FIELD INFORMATION (CONX04-058I) | JZ    | MAH   |        | RS    |              |       |                    |
| 1   |  | 03 02 11 | AS BUILT                                       | CAS   |       |        |       |              |       |                    |
| 0   |  | 02 11 04 | COMPRESSOR ADDITION - IFC                      | CJW   |       |        |       |              |       |                    |

|                           |      |
|---------------------------|------|
| APPROVED FOR CONSTRUCTION |      |
| DATE                      | REV. |
| PROJECT ENGINEERING       |      |

SEAL/STAMP

PERMIT