


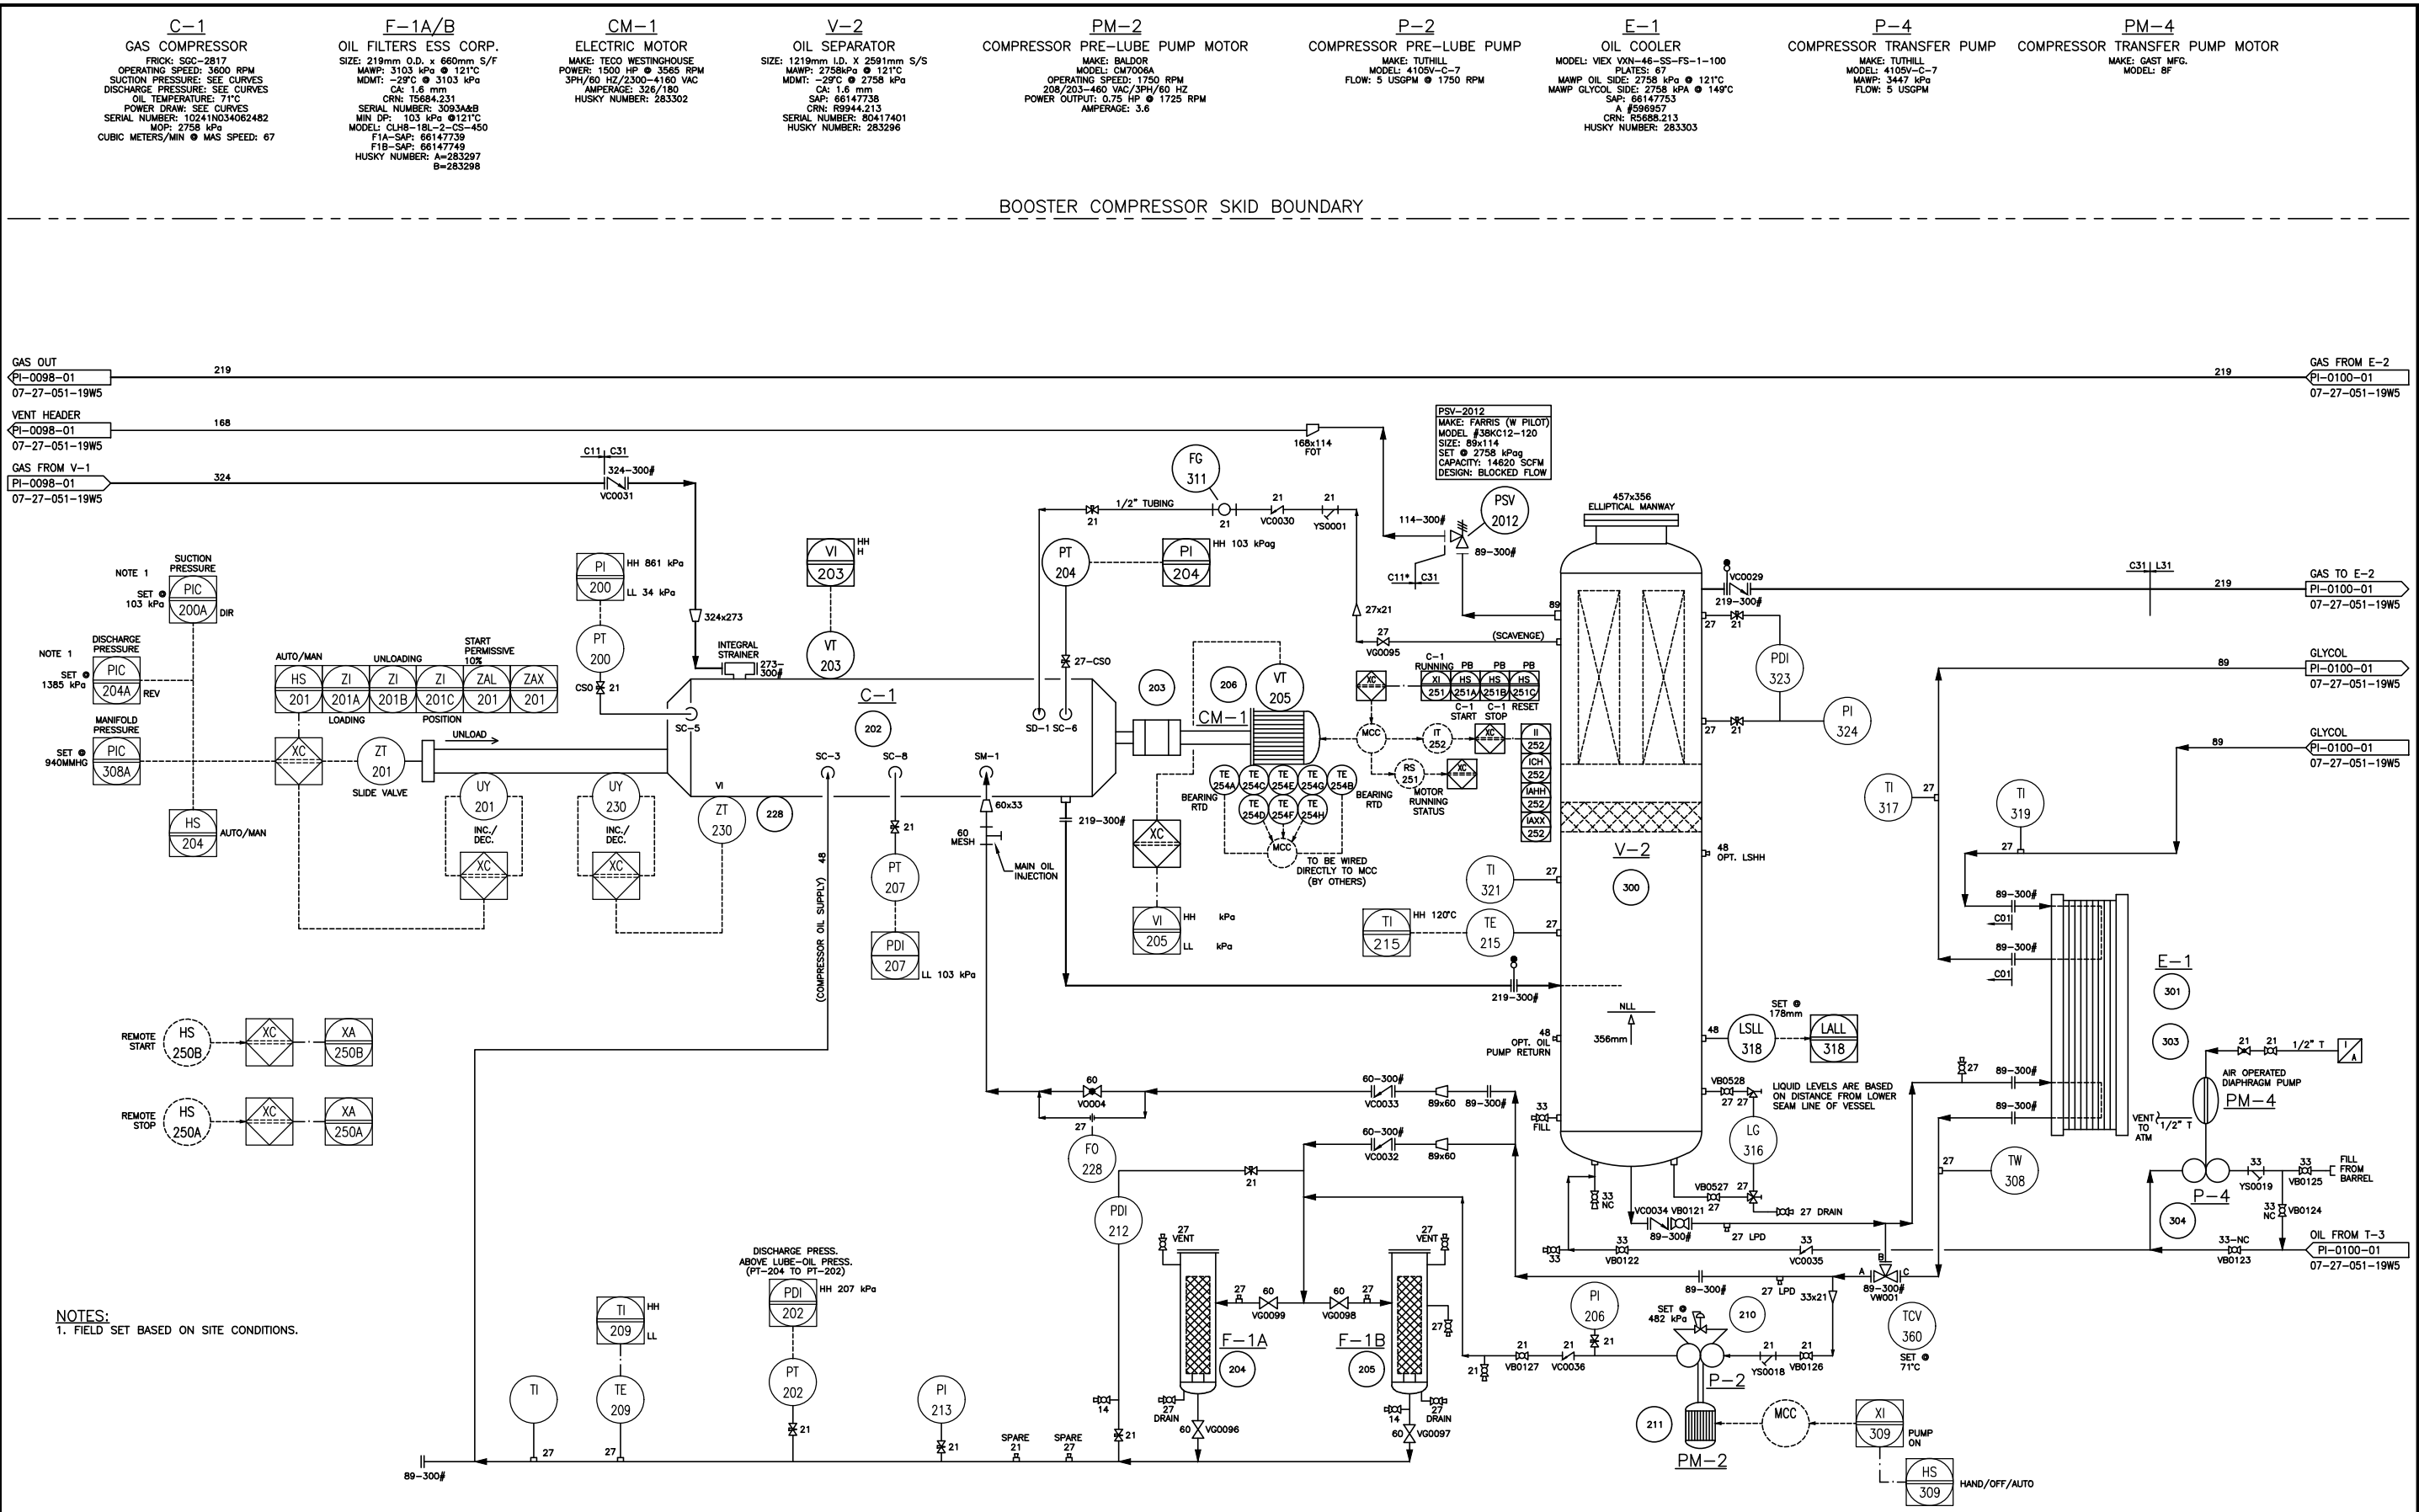

HUSKY OIL OPERATIONS LIMITED
2019/03/08
AS BUILT

REF DWG NO	REFERENCE DRAWING DESCRIPTION	NO	REVISION HISTORY	REV AUTHOR	REV DATE	ISSUED FOR	NO	CURRENT REVISION	ISSUED FOR AS BUILT
		1	INLET SCREW COMPRESSOR ADDITION FOR EWR 011603, GLE 08090	EPC_GLEL	2008/08/01	CONSTRUCTION	8	AS BUILT FOR E1 11051103 (TYLER MACKINNON)	DOC DATE 2019/08/15
		2	REVISED AS NOTED (EWR 011603, GLE 08090)	EPC_GLEL	2008/08/12	CONSTRUCTION			DOC AUTHOR KZ
		3	REVISED DRAWING NUMBERS (EWR 011603, GLE 08090)	EPC_GLEL	2008/08/22	CONSTRUCTION			SCALE NTS
		4	AS BUILT (GLE 08240)	EPC_GLEL	2009/02/17	AS-BUILT			ALTERNATE IDENTIFIER
		5	AS BUILT FOR CC 80026796	LG	2016/09/02	AS BUILT			SURFACE L&D
		6	AS BUILT FOR CC 80026796	KZ	2019/03/08	AS BUILT			07-27-051-19W5
		7	AS BUILT FOR CC 80026796	LG	2019/07/24	AS BUILT			DOCUMENT IDENTIFIER PI-0099-01

Husky Oil Operations Limited
ANSELL GAS PLANT #1 07-27-051-19W5
K-201 BOOSTER COMPRESSOR PACKAGE
PIPING & INSTRUMENTATION DIAGRAM

CAD DRAWING: DO NOT CHANGE MANUALLY