


CP-1
CONTROL PANEL
MAKE: TPS ALLEN BRADLEY
MODEL: COMPACT LOGIX
POWER: 24 VDC

V-1
COMPRESSOR SUCTION FILTER
HENRY MODEL #: RX-54102-490
SIZE: 1372mm I.D. x 2591mm S/S
M.A.W.P.: 1689 kPa @ 121°C
M.D.M.T.: -29°C @ 1689 kPa
C.A.: 1.6mm
CRN: 14574.213
S/N: C250777A-2
MODEL #: RX-54102-490
A NUMBER: 586795
HUSKY NUMBER: 283293
SAP: 66147737

H-1A/B
BUILDING HEATERS
MAKE: RUFFNECK ELECTRIC
MODEL: FX420-480360-30
POWER: 30kw (102, 350 BTU/HR)/3/60/480 VAC

NOTES:
1. FLARE & HC DRAIN TO SLOPE INTO COMPRESSOR PACKAGE DUE TO LOWER ELEVATION THAN HEADER TIE-INS.
2. LOCATE VALVE SO THAT THE OPERATOR CAN SEE LG-110 WHILE HOLDING THE VALVE OPEN.

BOOSTER COMPRESSOR SKID BOUNDARY

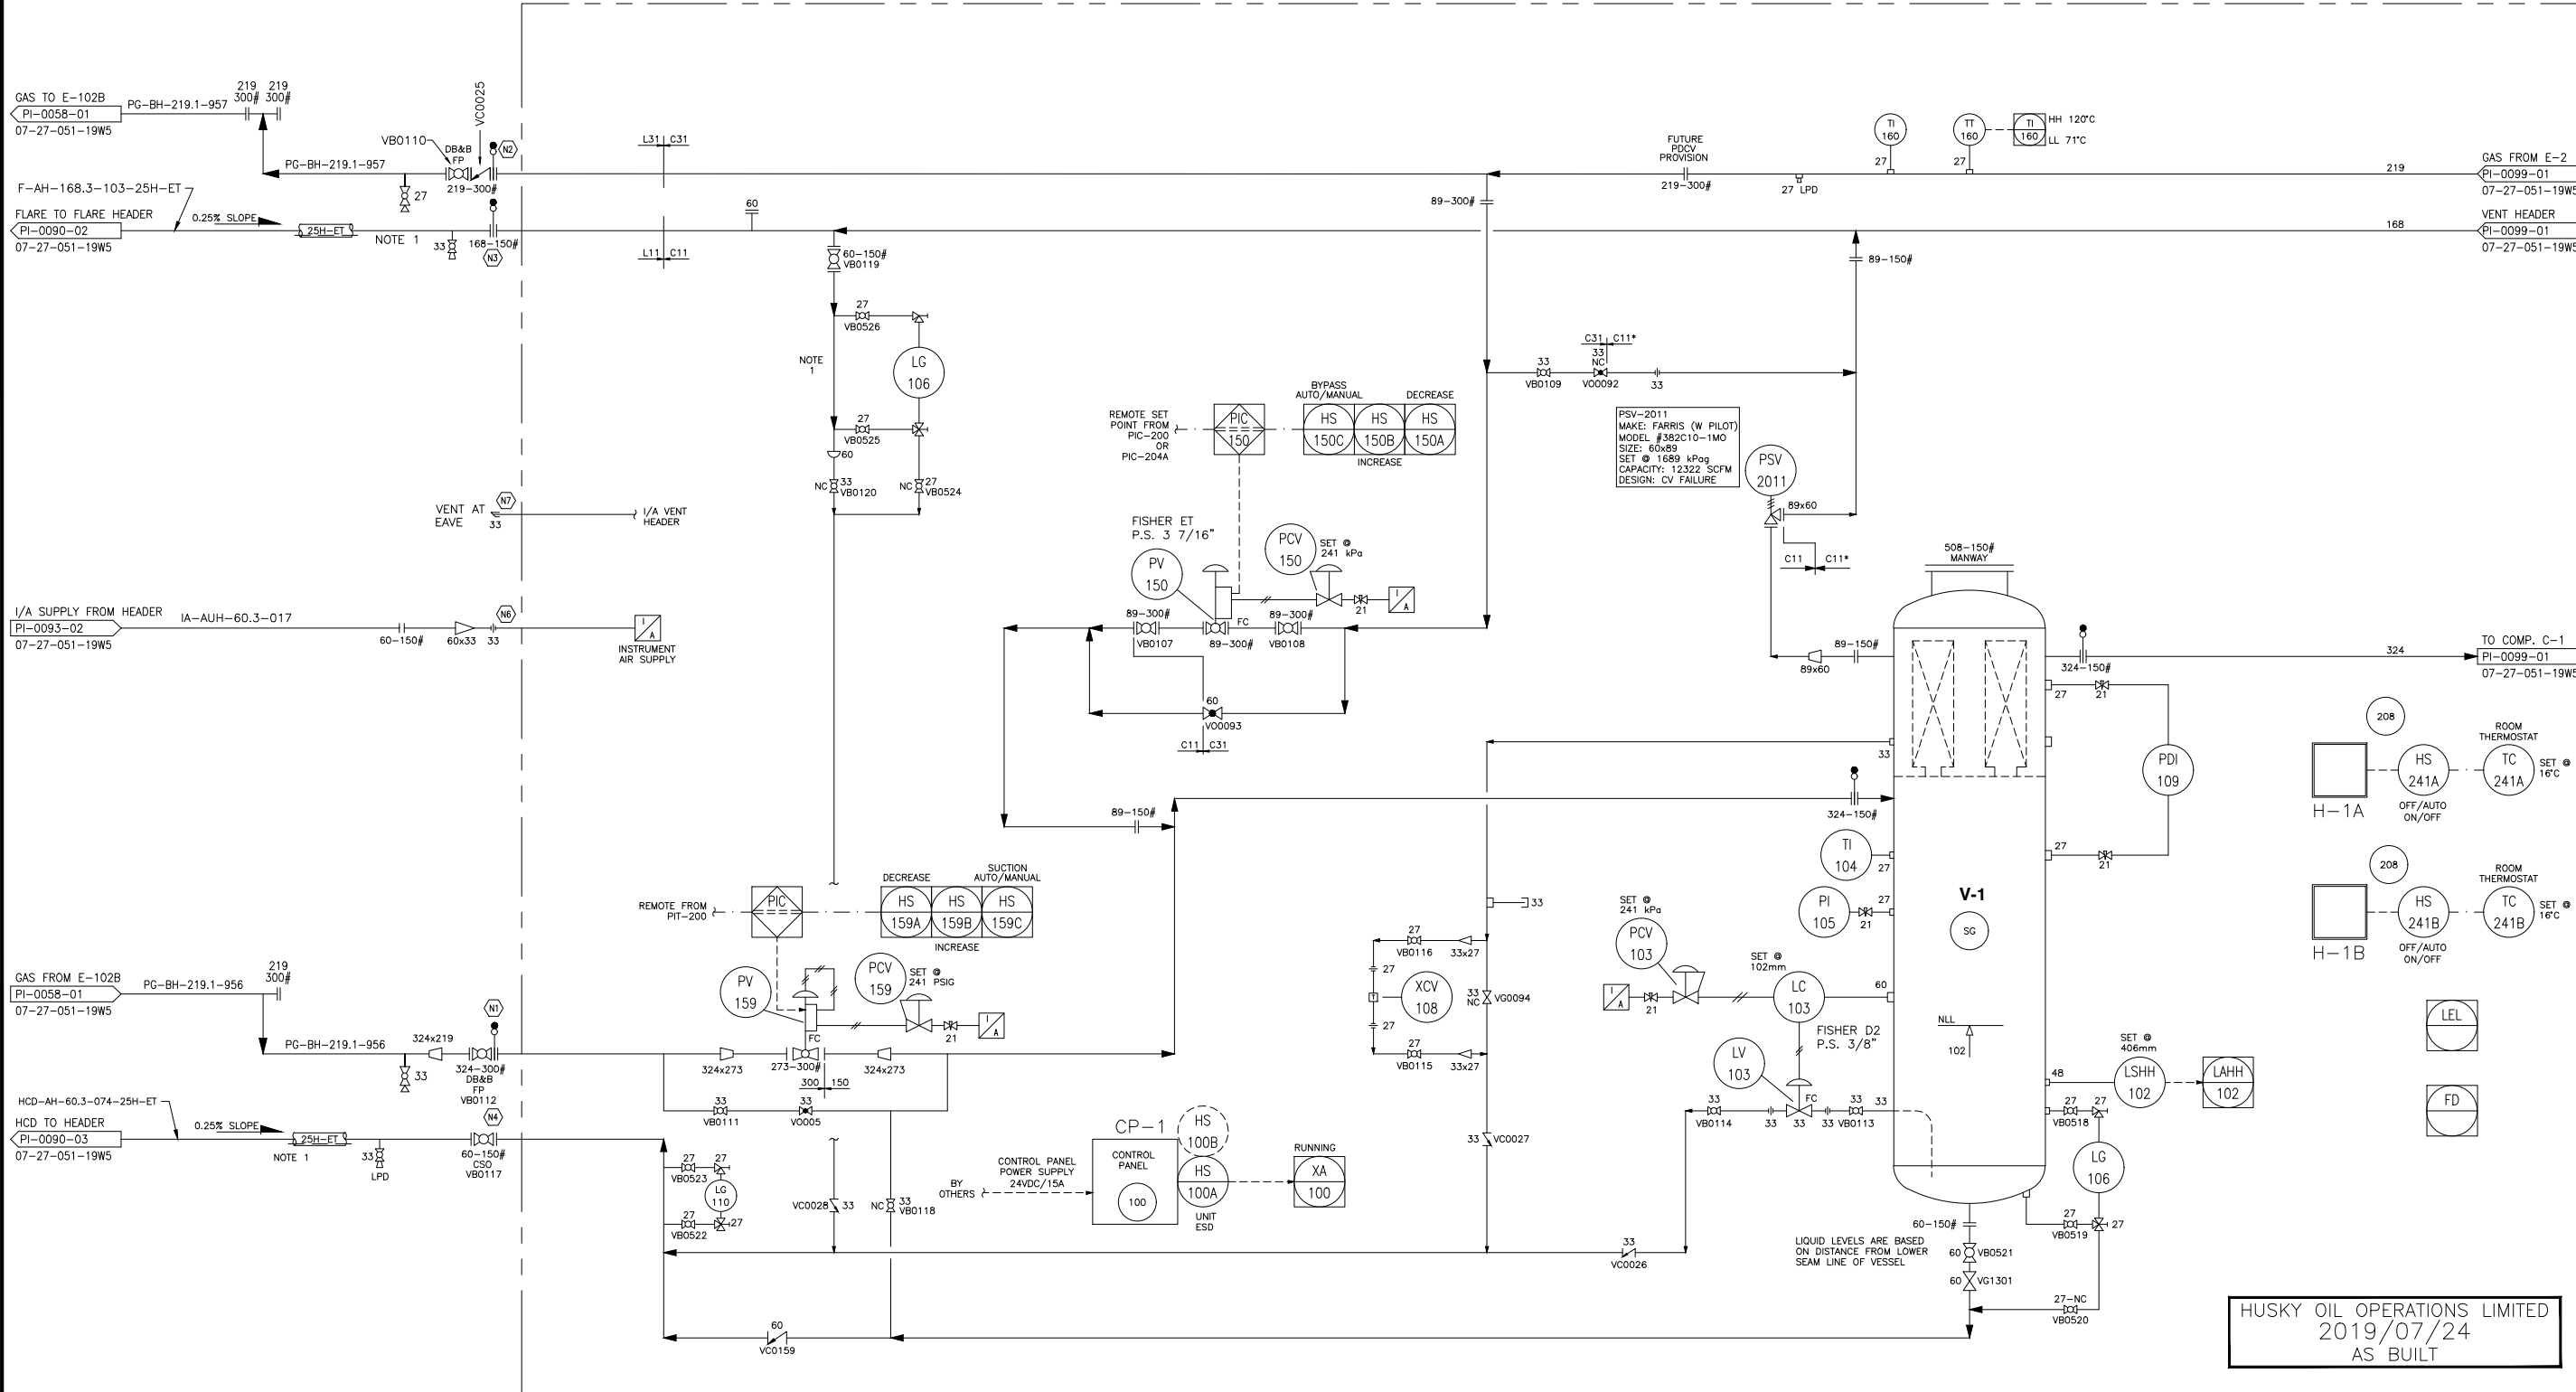

HUSKY OIL OPERATIONS LIMITED
2019/07/24
AS BUILT

REF DWG NO	REFERENCE DRAWING DESCRIPTION	NO	REVISION HISTORY	REV AUTHOR	REV DATE	ISSUED FOR	NO	CURRENT REVISION	ISSUED FOR
		8	AS BUILT FOR CC 80026796	SK	2019/07/03	AS BUILT	9	AS BUILT FOR CC 80026796	AS BUILT
		2	REVISED AS NOTED (EWR 011603, GLE 08090)	EPC_GLEL	2008/08/12	CONSTRUCTION			DOC DATE 2019/07/24
		3	REVISED DRAWING NUMBERS & AS NOTED (EWR 011603, GLE 08090)	EPC_GLEL	2008/08/22	CONSTRUCTION			DOC AUTHOR LG
		4	AS BUILT (GLE 08240)	EPC_GLEL	2009/02/17	AS BUILT			SCALE NTS
		5	IFC FOR EWR 16331 EXCELSIOR 3244	EXCELSIOR	2012/12/06	CONSTRUCTION			ALTERNATE IDENTIFIER
		6	AS BUILT FOR CC 80026796	LG/KZ	2016/09/02	AS BUILT			SURFACE LSD 07-27-051-19W5
		7	AS BUILT FOR CC 80026796	KZ	2019/03/08	AS BUILT			DOCUMENT IDENTIFIER PI-0098-01

Husky Oil Operations Limited
ANSELL GAS PLANT #1 07-27-051-19W5
K-201 BOOSTER COMPRESSOR PACKAGE
PIPING & INSTRUMENTATION DIAGRAM

CAD DRAWING: DO NOT CHANGE MANUALLY