


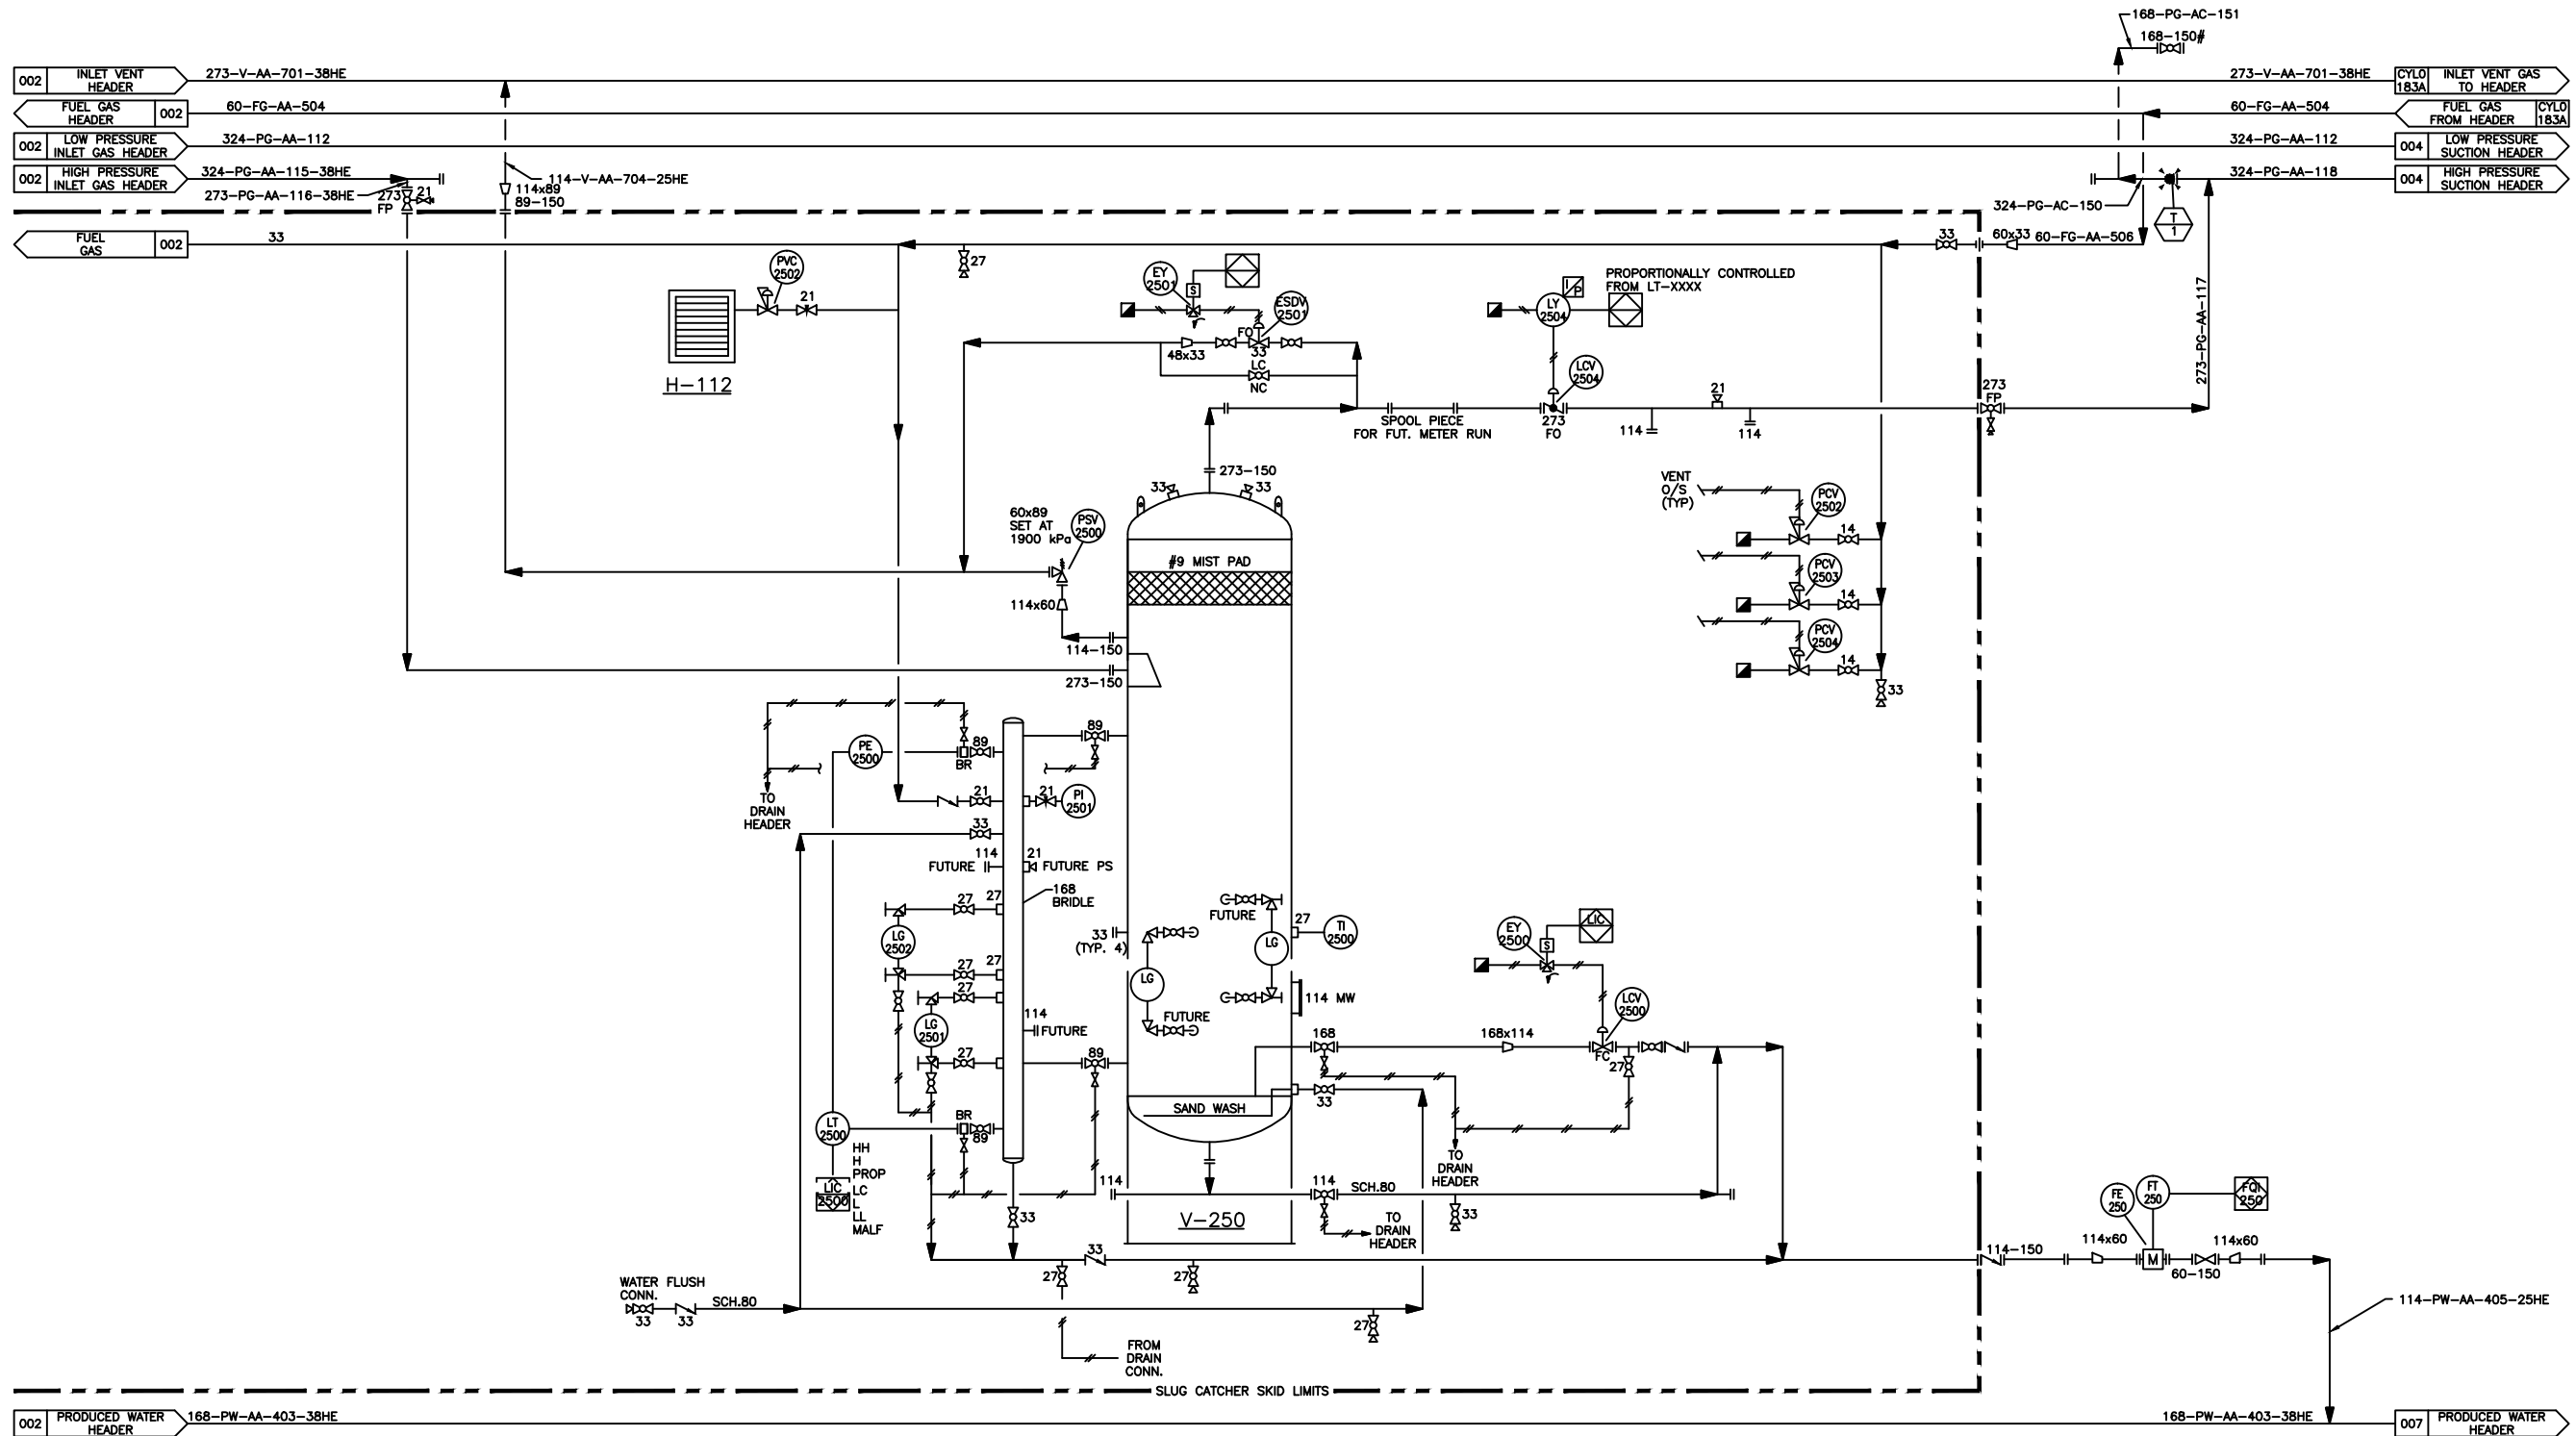

H-112
BUILDING HEATER
VENDOR: BROMLEY
MAKE/MODEL: OISCAN CATALYTIC
DUTY: 30,000 BTU/HR
START: 120 V

V-250
HP SLUG CATCHER/SEPARATOR
VENDOR: BROMLEY
MAKE/MODEL: VERTICAL SLUG CATCHER
SIZE: 1219mm ID x 19.05mm WT x 3048mm S/S
D.P.: 1965 kPag

SEGMENT ENGINEERING
OIL & GAS EPC SERVICES

REFERENCE DRAWINGS	DWG. NO.
-	-
-	-
-	-
-	-
-	-
-	-

NO.	DATE	PROJECT DESCRIPTION	PROJ.	AFE	EPCM Co.	EPCM No.	APPD.
1	04.01.12	CLYDE LAKE COMPRESSOR STATION	-	-	GRB	9107	-
2	06.05.15	COMPRESSOR ADDITION	06CLP8-9	H2P INC.	56-002	-	-
3	08.08.13	K-700 COMPRESSOR REMOVAL & ADDED FE-150/250 (AS-BUILT)	-	-	SEGMENT	2325	-
-	-	-	-	-	-	-	-
-	-	-	-	-	-	-	-
-	-	-	-	-	-	-	-
-	-	-	-	-	-	-	-
-	-	-	-	-	-	-	-
-	-	-	-	-	-	-	-
-	-	-	-	-	-	-	-
-	-	-	-	-	-	-	-

CAUTION : READ BEFORE EXCAVATION
ALL EXCAVATIONS MUST BE CARRIED OUT AS PER
Cenovus Energy Inc. "GROUND DISTURBANCE PRACTICES"

ISSUE STAGE	DATE	BY	CHKD.	APPD.
Prelim.(1A1)	00-12-20	CG	LK	RG
Bld	01.02.01	CHD	LK	RG
Contrb(1C1)	01.02.13	GHD	LK	RG
As-built	01.07.10	GHD	AP	RG
Apptl (2A1)	06.04.19	JR	LB	LBN
Contrb(2C1)	06.06.02	DC	LBN	BL
Contrb(3C1)	07.06.13	GA	IC	GJ
As-built(3D)	07.11.05	AS	IC	GJ

REV. NO.	FORMAT	REV. DATE	REV. BY	REV. CHKD.	REV. APPD.
1	A	07.11.05	AS	IC	GJ

PERMIT STAMP	ENGINEER'S STAMP
SEGMENT ENGINEERING INC'S PERMIT TO PRACTICE PERMIT No. P 0514 WAS AFFIXED TO REV. 3C1 OF THIS DRAWING AND WAS SIGNED BY GREG JUNEAU ON AUG. 13, 2007	REVISION 3C1 OF THIS DRAWING WAS P. ENG STAMPED AND SIGNED BY GREG JUNEAU ON AUG. 13, 2007

PERMIT STAMP AND PROFESSIONAL STAMP AFFIXED ABOVE SHALL APPLY ONLY TO REV(s)

cenovus ENERGY	COMP. STN. 08-09
	08-09-072-09 W4M
	COMPRESSOR STATION
	08-09-072-09 W4M
SCALE: NTS (A1 Size)	2325
SEGMENT ENGINEERING INC.	
TITLE: PIPING AND INSTRUMENTATION DIAGRAM SLUG CATCHER V-250	

AREA: CLYDE LAKE	CLASS FILE NO.: A	CYL0176A
------------------	-------------------	----------